


⊕ **FLOOR PLAN**
SCALE : 1/2"=1'-0"

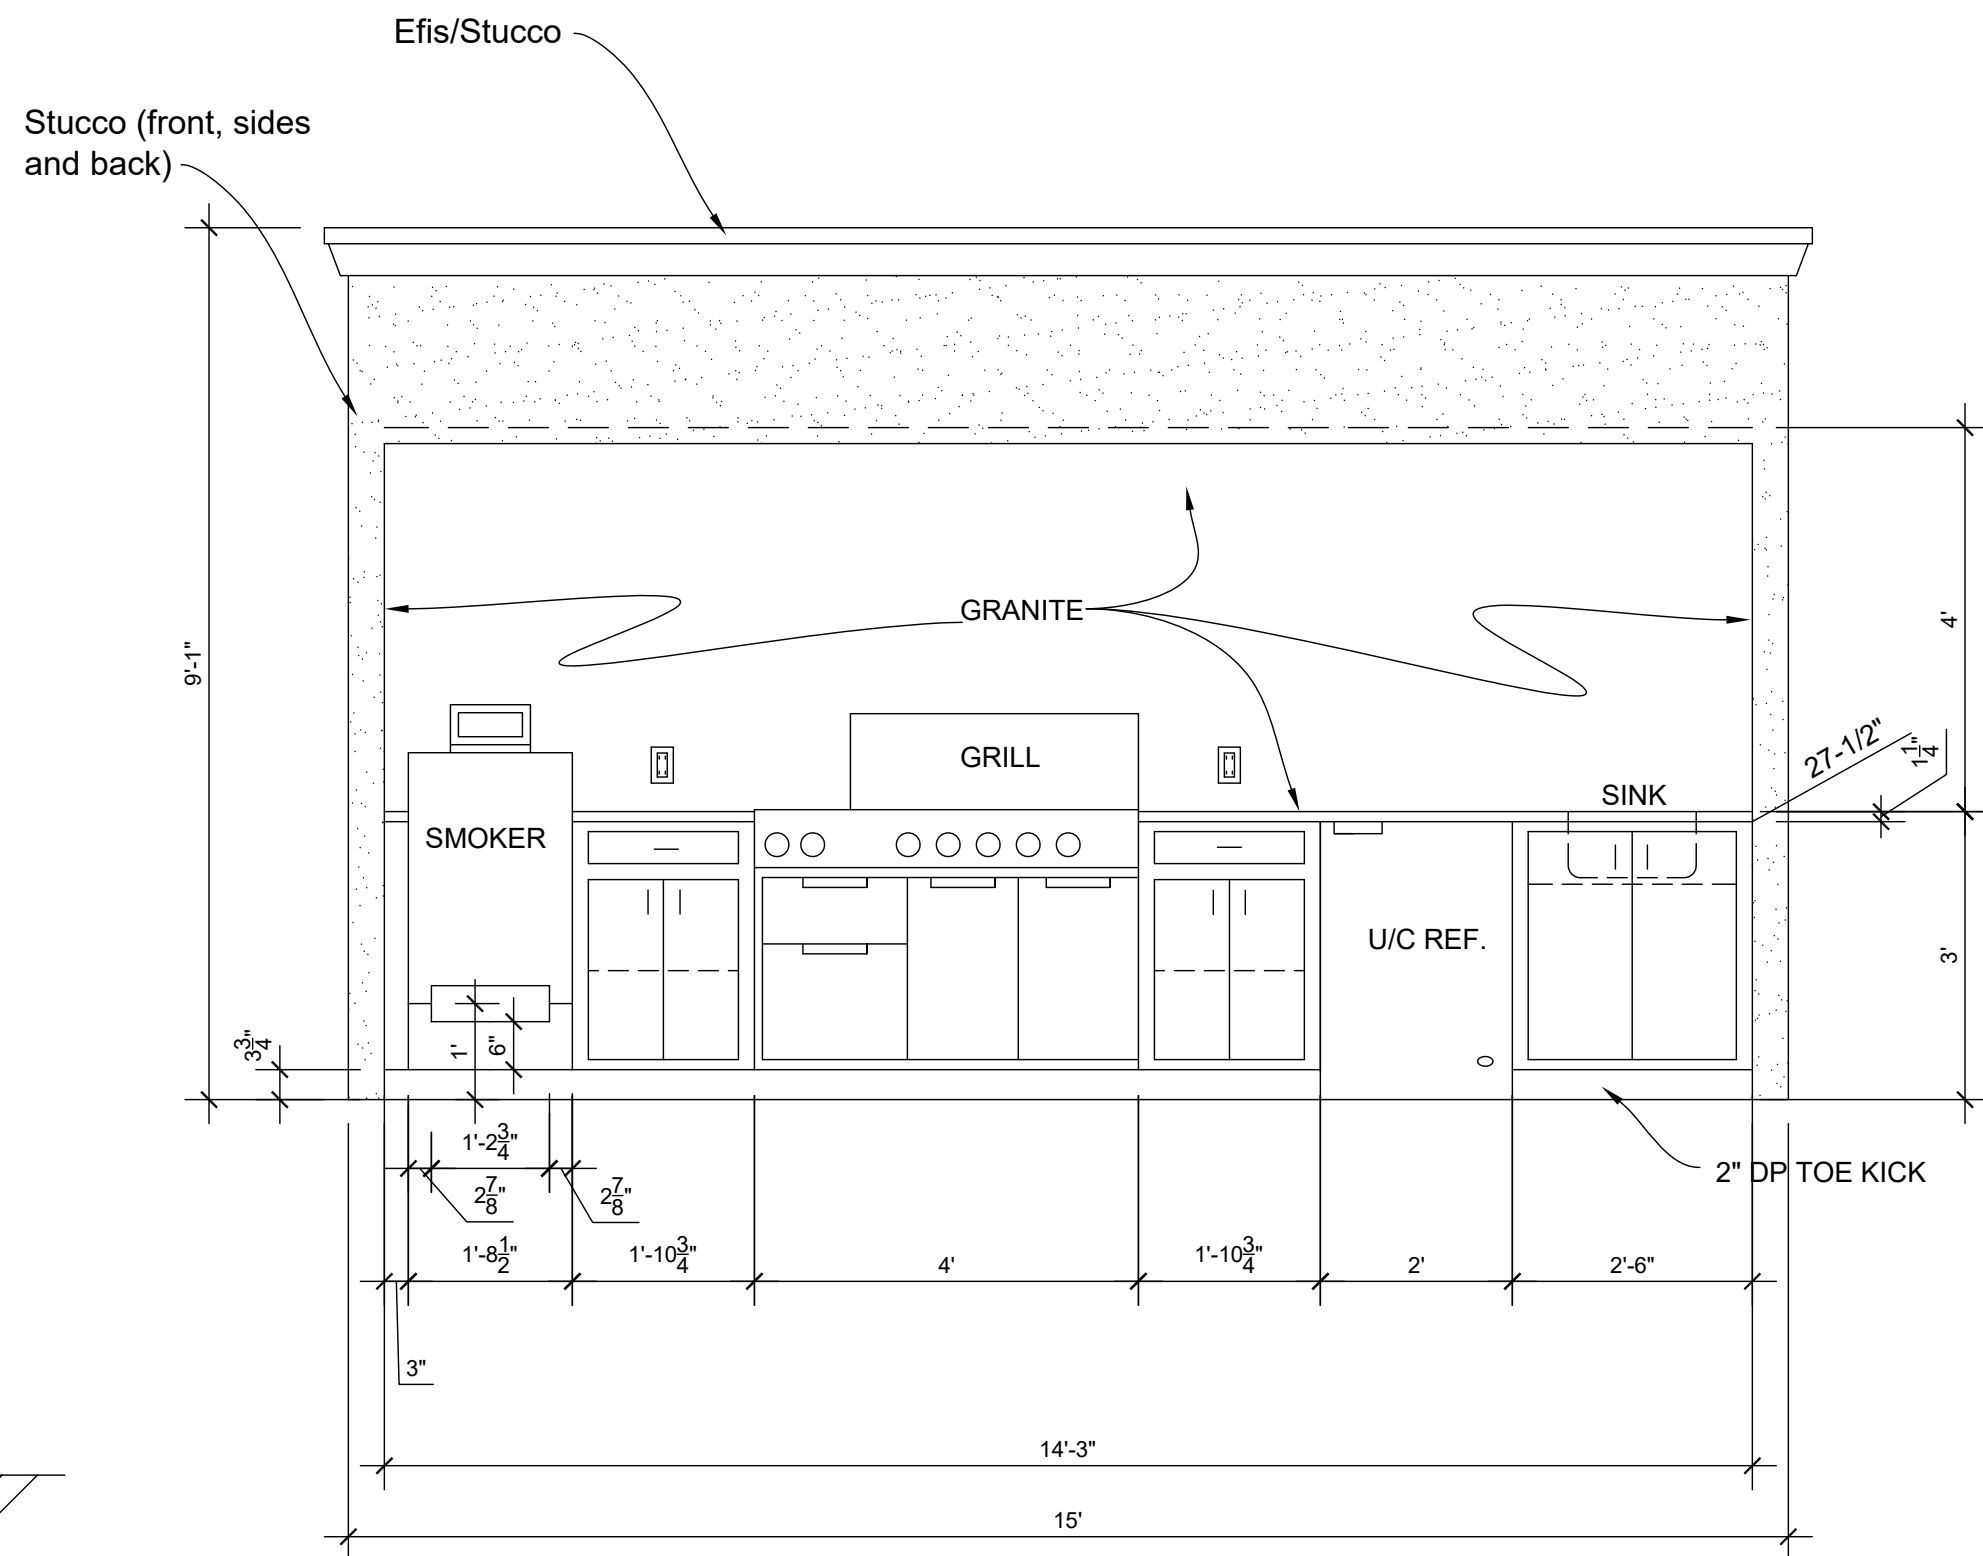

⊕ **ELEVATION**
SCALE : 1/2"=1'-0"

THIS DRAWING AND ALL INFORMATION THEREON IS THE PROPRIETARY PROPERTY OF TREND BUILDERS AND MUST NOT BE MADE PUBLIC OR COPIED. THIS DRAWING IS TO BE USED ONLY FOR THE PROJECT AND IS NOT TO BE USED DIRECTLY OR INDIRECTLY IN ANY WAY DETRIMENTAL TO THE INTEREST OF TREND BUILDERS.


| REV'S | NO. | DATE | DESCRIPTION |
|-------|----------|------|-------------|
| 4 | 00/00/00 | | |
| 3 | 00/00/00 | | |
| 2 | 00/00/00 | | |
| 1 | 00/00/00 | | |

PROJECT: **Outdoor Kitchen**
DRAWING: **Plan / Elevation**

CUSTOMER:


TREND BUILDERS

DATE: 4/15/09
SHEET: 1 of 3

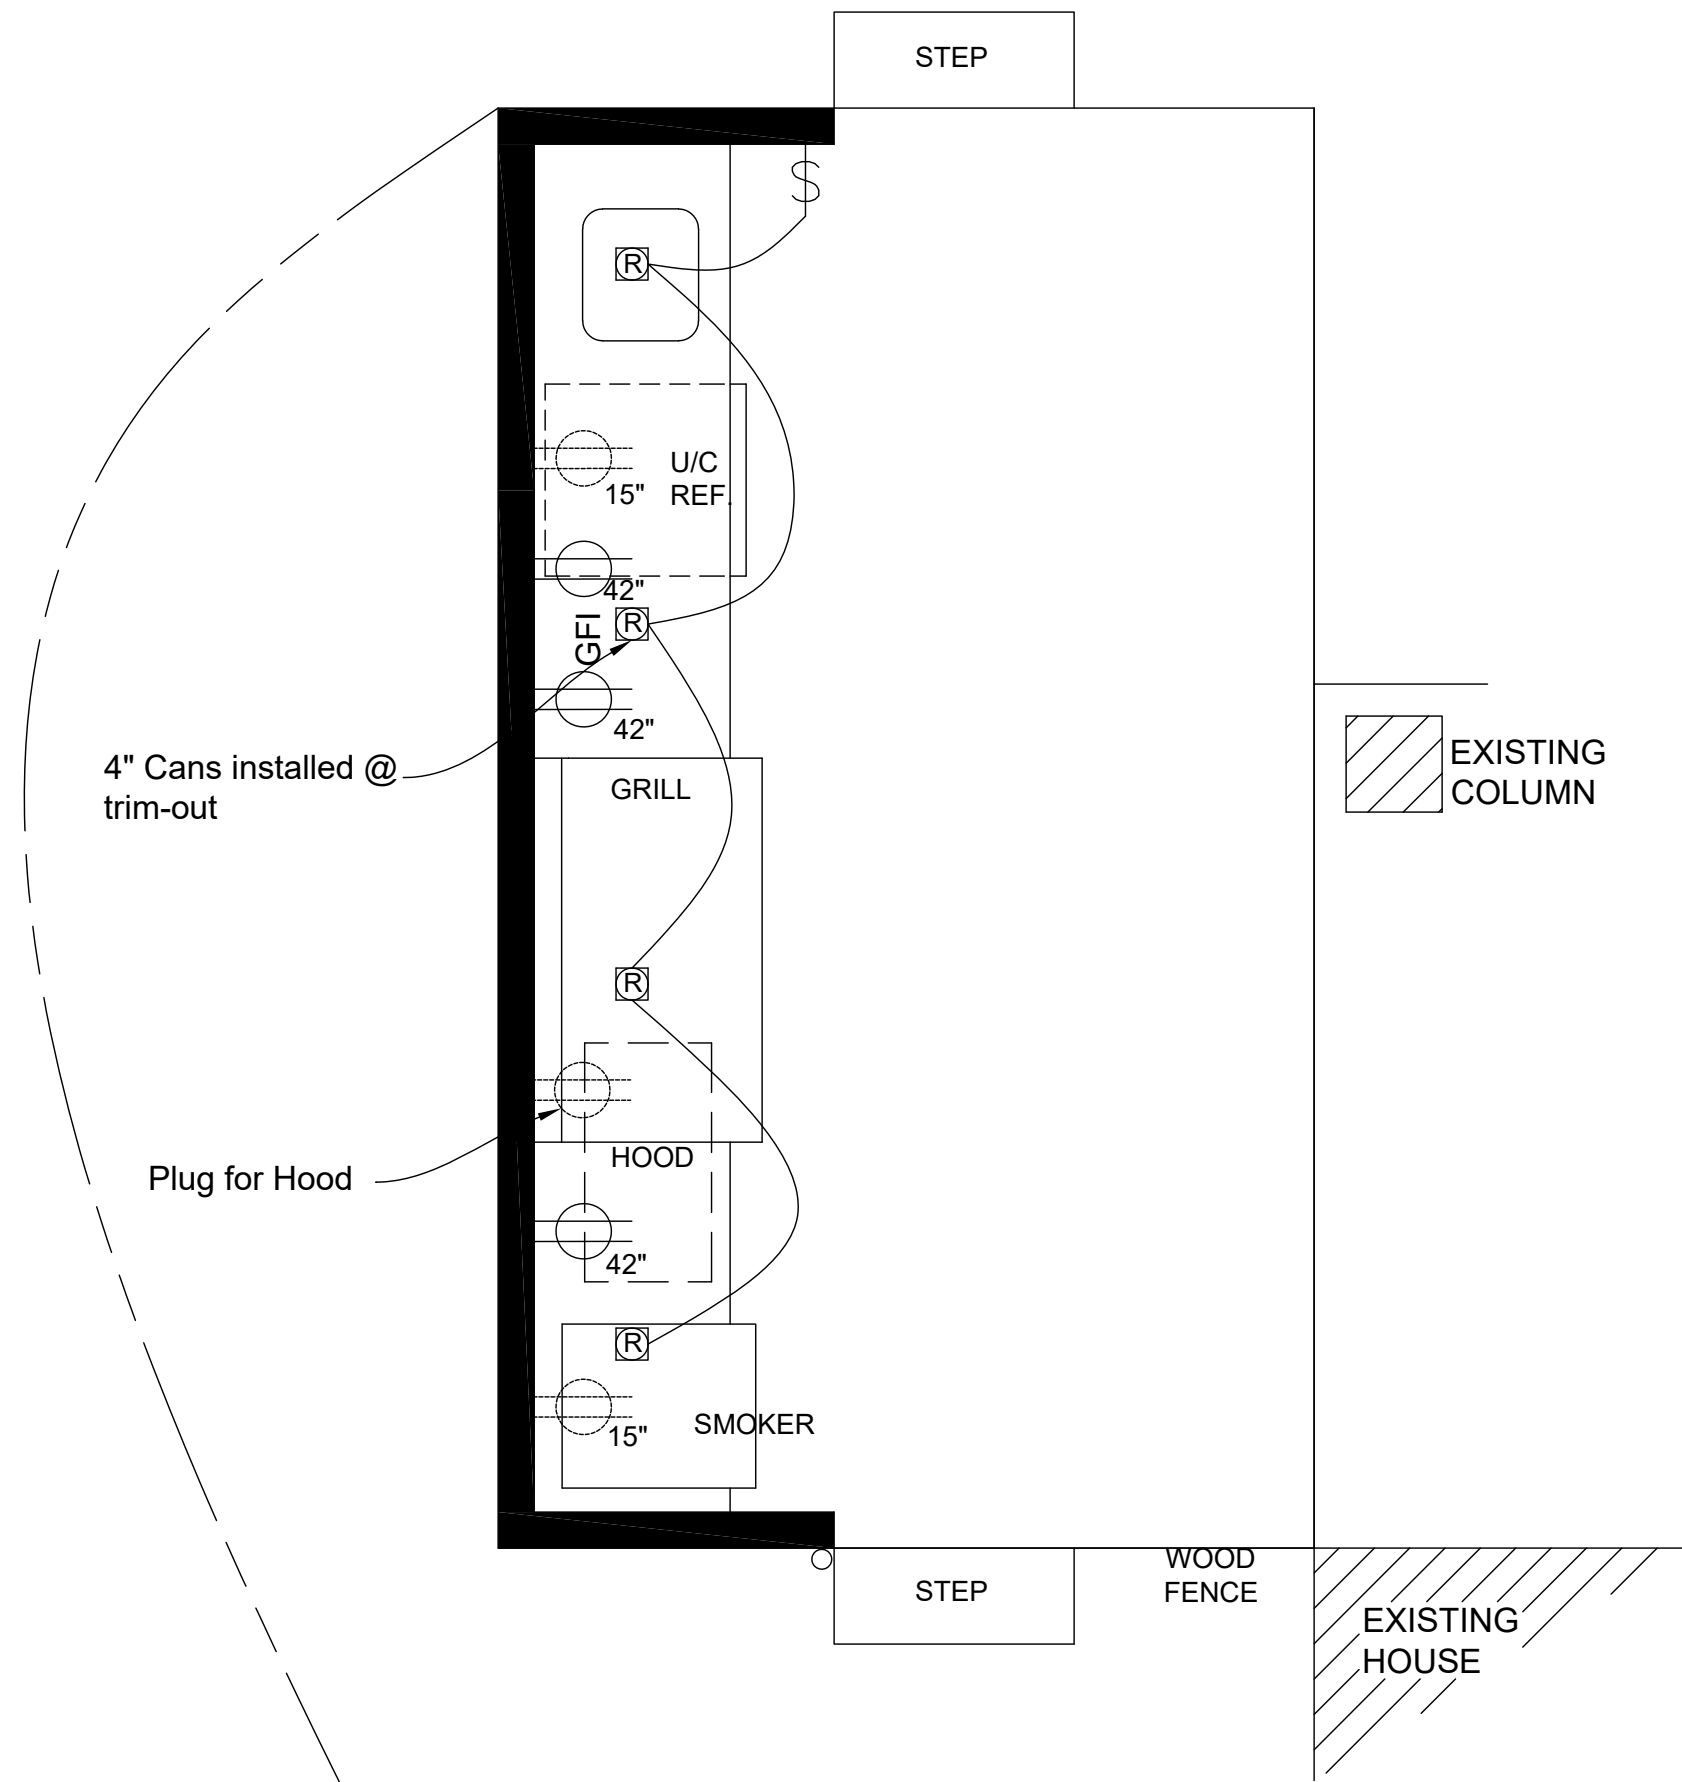


1
2 ELECTRICAL PLAN
SCALE : 1/2"=1'-0"


2 - 20 amp circuits back to panel

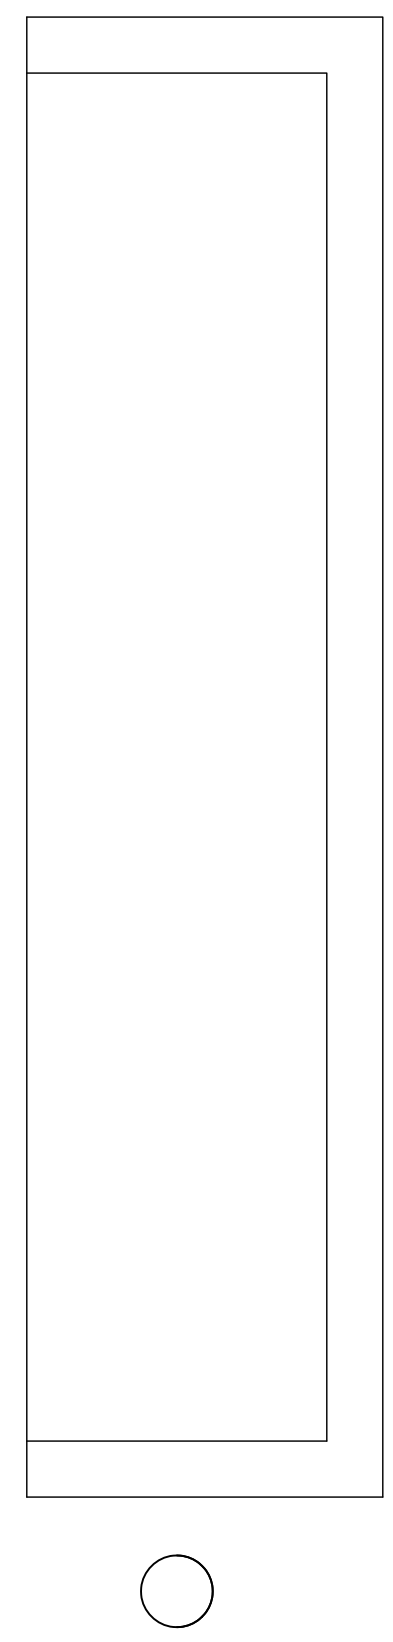

2
2 SHEET MEAL CAP
SCALE : 1/2"=1'-0"

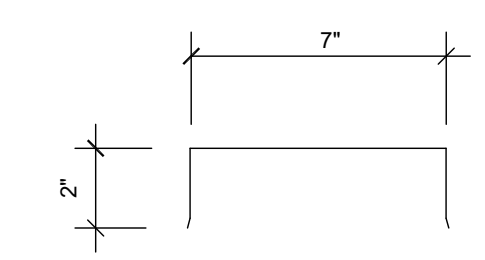

4
2 CAP SECTION
SCALE : 1/2"=1'-0"

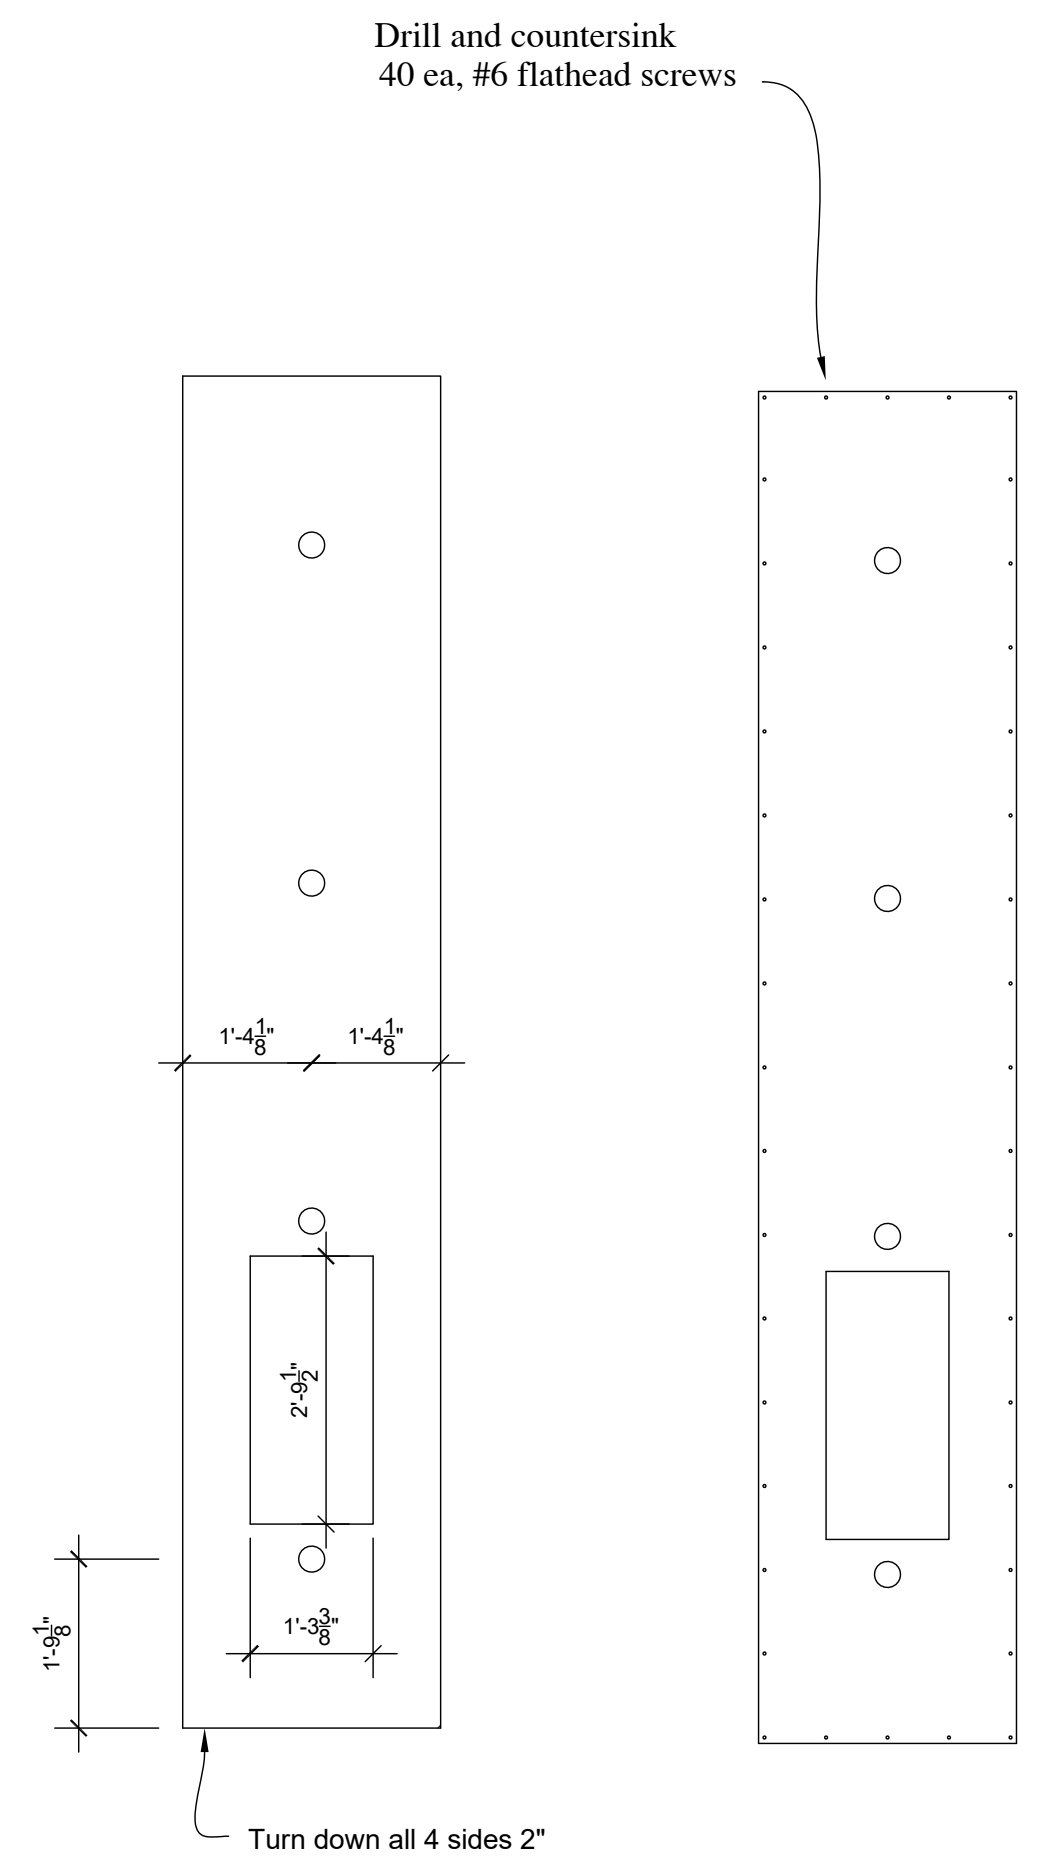

3
2 STAINLESS CLG
SCALE : 1/2"=1'-0"

Drill and countersink
40 ea, #6 flathead screws

Turn down all 4 sides 2"

THIS DRAWING AND ALL INFORMATION THEREON IS THE PROPRIETARY PROPERTY OF TREND BUILDERS AND MUST NOT BE MADE PUBLIC OR COPIED. THIS DRAWING IS LOANED TO YOU FOR USE ONLY AND IS NOT TO BE REPRODUCED, COPIED, OR USED IN ANY MANNER, DIRECTLY OR INDIRECTLY, IN ANY WAY DETRIMENTAL TO THE INTEREST OF TREND BUILDERS.


| REV | NO. | DATE | DESCRIPTION |
|-----|-----|----------|-------------|
| 4 | Δ | 00/00/00 | |
| 3 | Δ | 00/00/00 | |
| 2 | Δ | 00/00/00 | |
| 1 | Δ | 00/00/00 | |

PROJECT: **Outdoor Kitchen**
DRAWING: **Plan / Electrical**

CUSTOMER:

TREND BUILDERS

DATE: 4/15/09
SHEET: 2 of 3

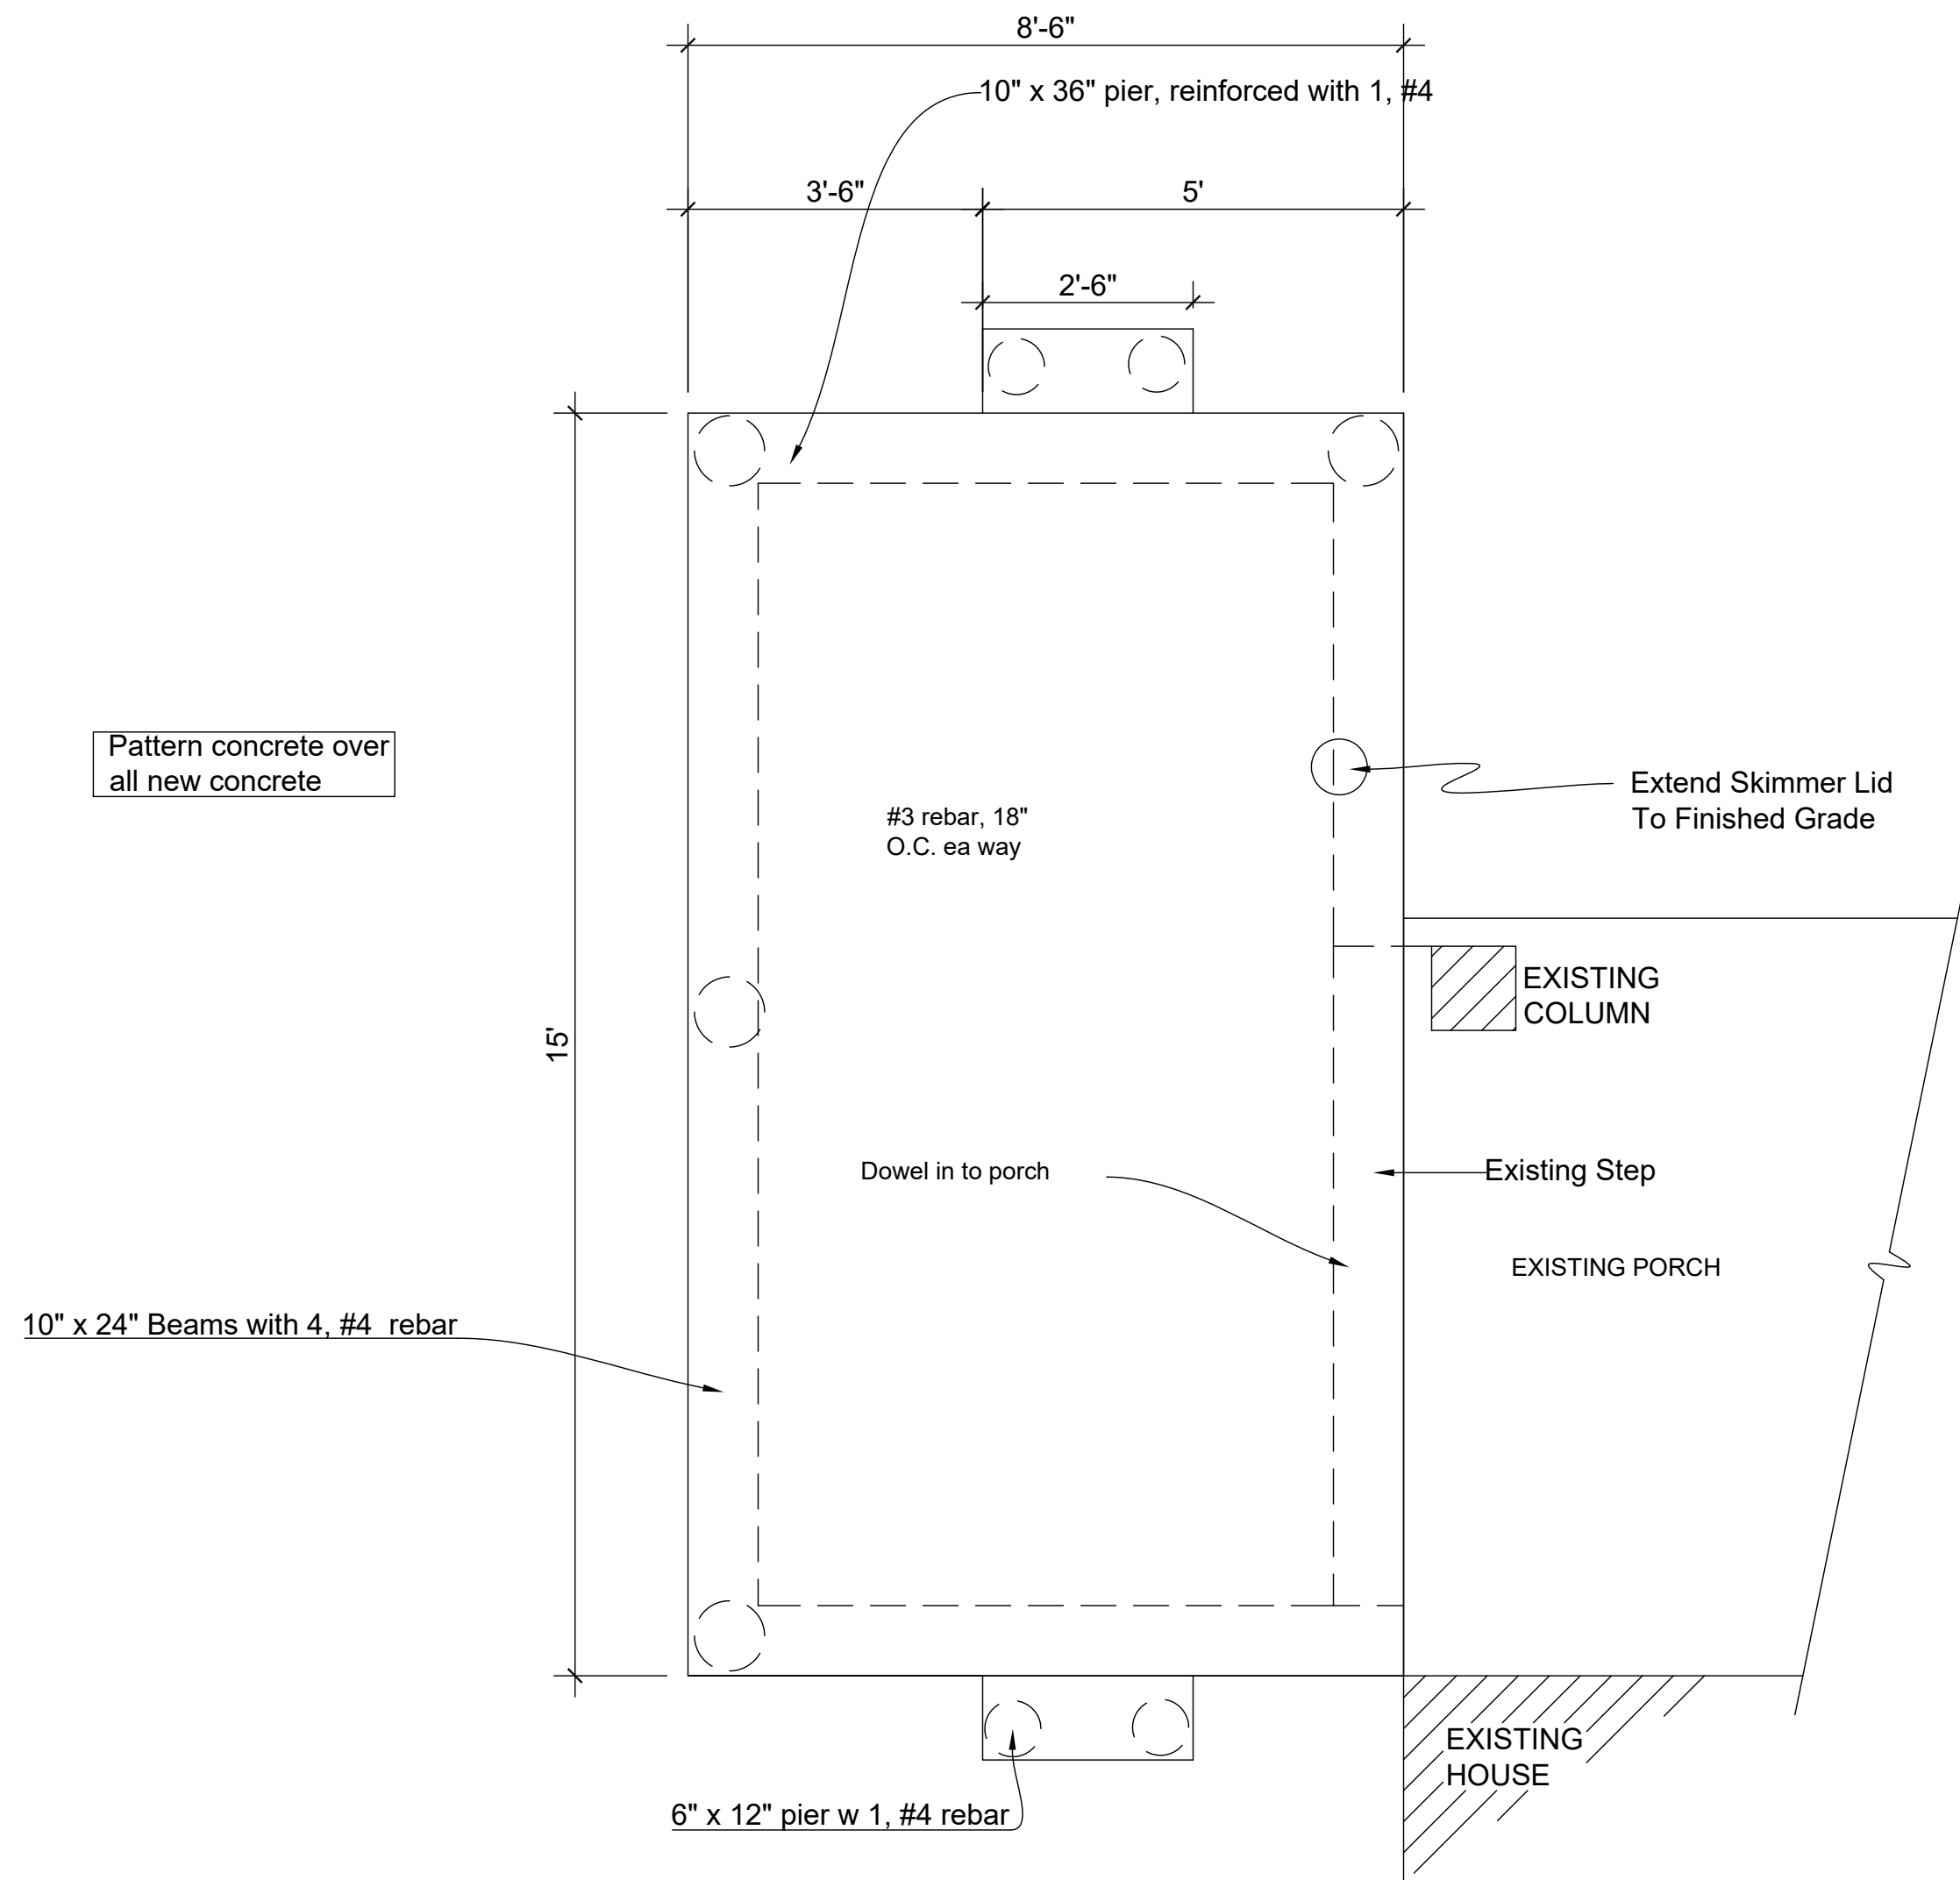


1
3

Foundation

SCALE : 1/2"=1'-0"

| | |
|--|-------------------|
| <p>THIS DRAWING AND ALL INFORMATION THEREON IS THE PROPRIETARY PROPERTY OF TREND BUILDERS AND MUST NOT BE MADE PUBLIC OR COPIED. THIS DRAWING IS LOANED AND IS NOT TO BE USED DIRECTLY OR INDIRECTLY IN ANY WAY DETRIMENTAL TO THE INTEREST OF TREND BUILDERS.</p> | |
| REF. VISIONS No. | Description |
| 4 | 00/00/00 |
| 3 | 00/00/00 |
| 2 | 00/00/00 |
| 1 | 00/00/00 |
| <p>CUSTOMER:</p> <p>TREND BUILDERS</p> | |
| PROJECT | Outdoor Kitchen |
| DRAWING: | Plan / Foundation |
| DATE: | 4/20/09 |
| SHEET: | 3 of 3 |

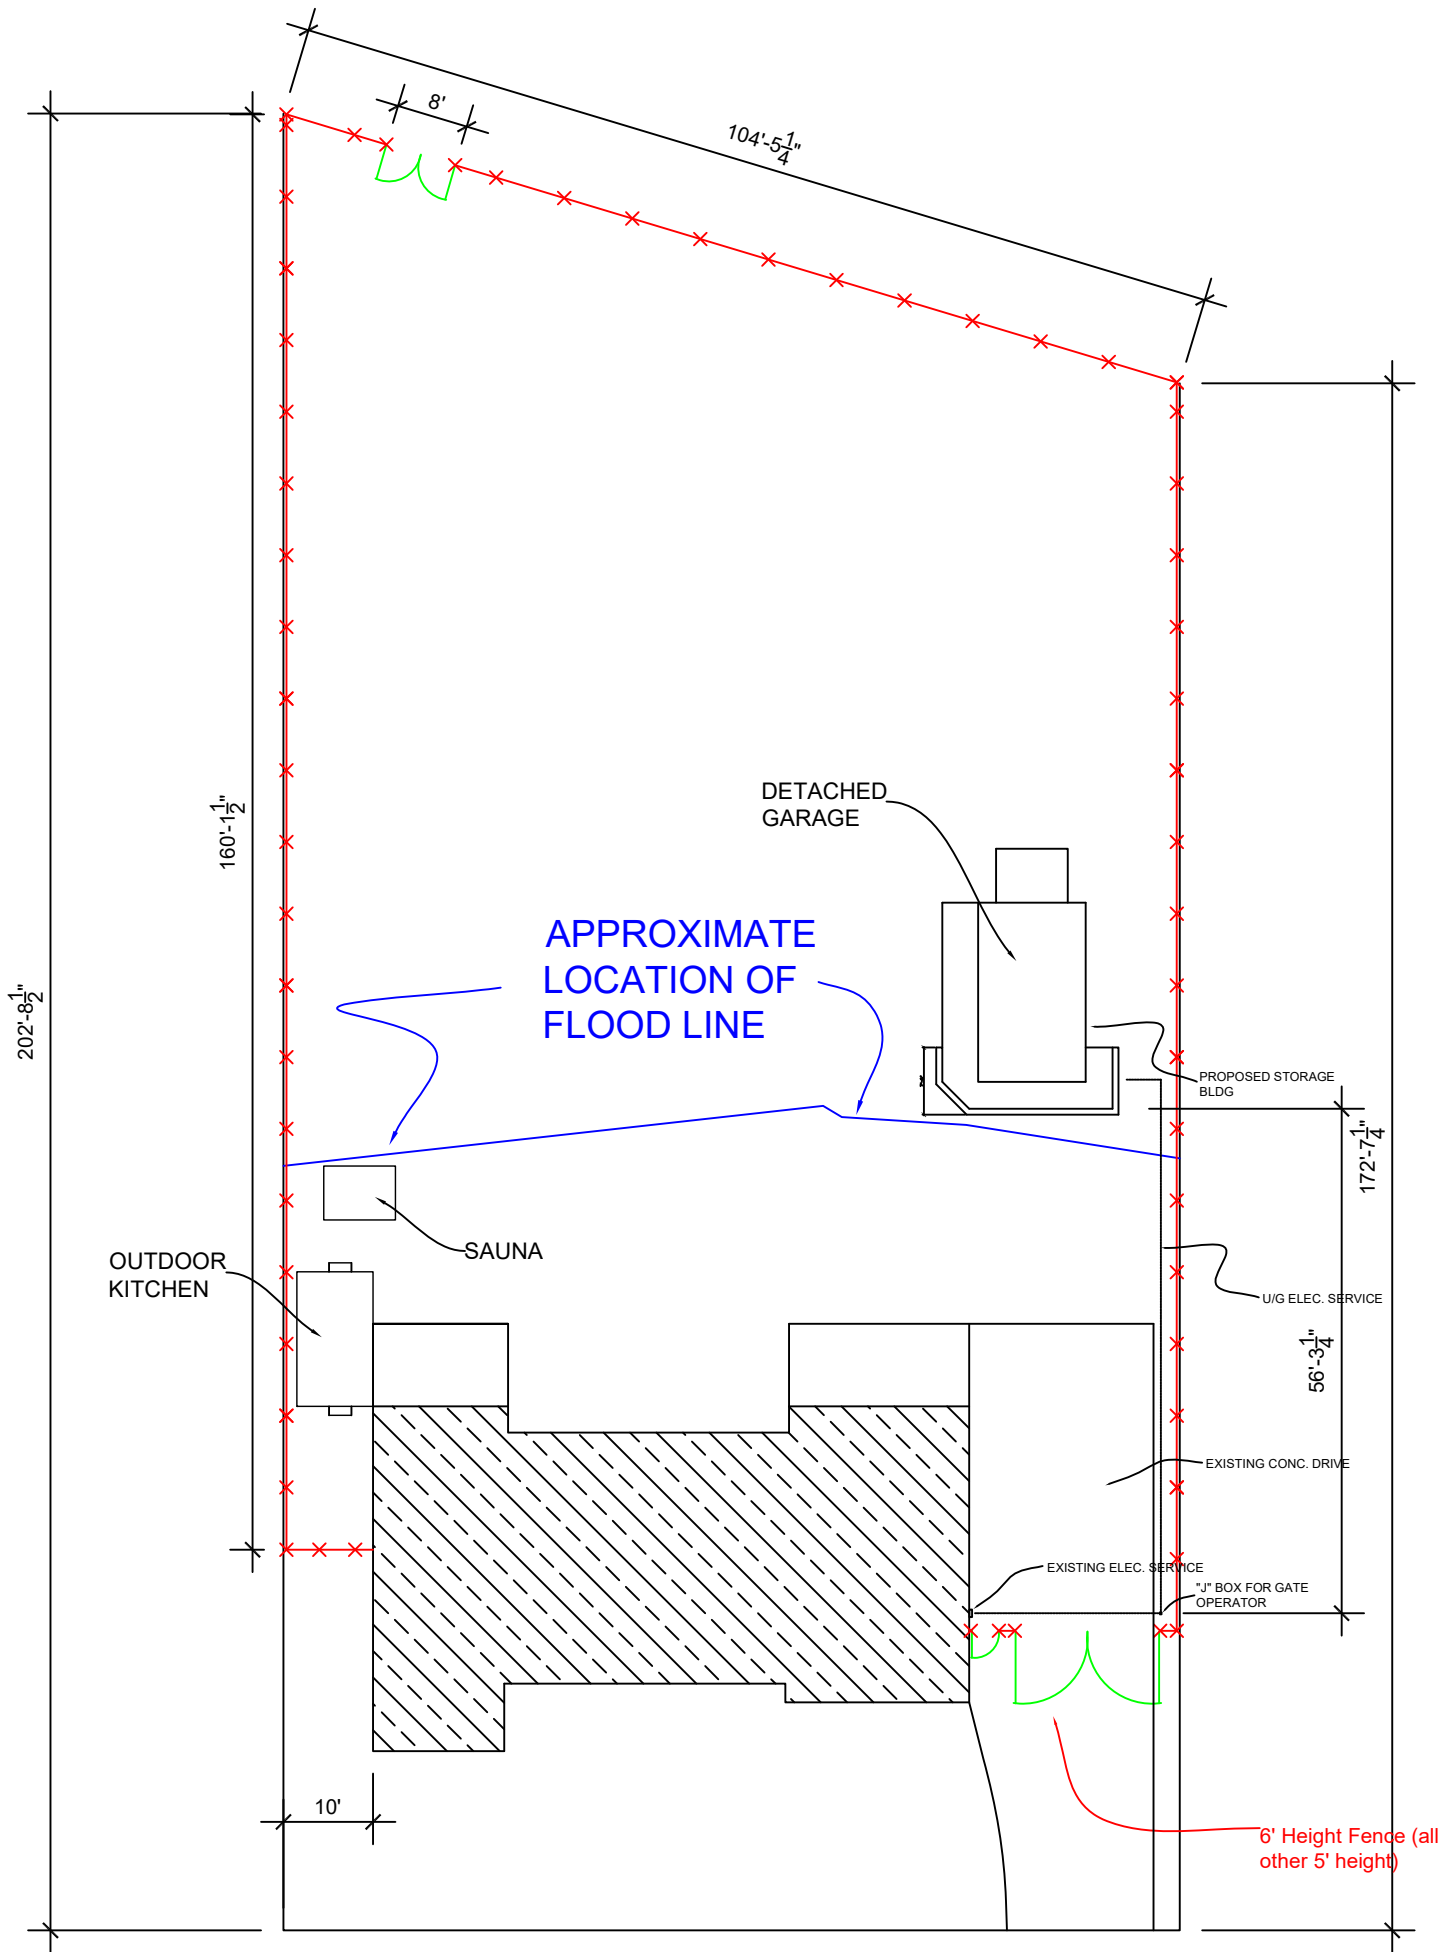

Scale 13/16"
=20'-0"

| | | | | | |
|-------------------------------|--|-----------|--------------------------|---|--|
| DATE: 1/4/08 SHEET: 1 OF 1 | | CUSTOMER: | PROJECT: Garage/Fence | REVISIONS No. Date Description Δ 00/00/00 Δ 00/00/00 Δ 00/00/00 Δ 00/00/00 | THIS DRAWING AND ALL INFORMATION THERON IS THE PROPRIETARY PROPERTY OF TREND BUILDERS AND MUST NOT BE MADE PUBLIC OR COPIED. THIS DRAWING IS LOANED SUBJECT TO RETURN ON DEMAND AND IS NOT TO BE USED, DIRECTLY OR INDIRECTLY, IN ANY WAY DETRIMENTAL TO THE INTEREST OF TREND BUILDERS. |
| | | | DRAWING: Plot Plan | | |