




1
1 AS-BUILT FLOOR PLAN
Scale 1/4" = 1'-0"

CLEAN - OUTS

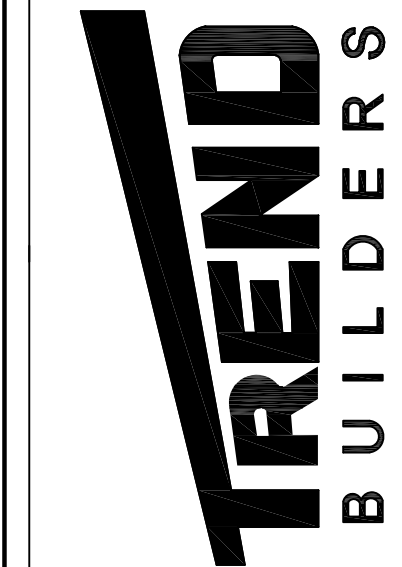

CUSTOMER:

PROJECT:
Interior Renov.

DRAWING:

As-Built Plan

DATE:

12/20/17

SHEET:

1 OF 5

REVISIONS
No. Date Description


4 00/00/00

3 00/00/00

2 00/00/00

1 00/00/00

THIS DRAWING AND ALL INFORMATION THEREON IS THE PROPRIETARY PROPERTY OF TREND BUILDERS AND MUST NOT BE MADE PUBLIC OR COPIED. THIS DRAWING IS LOANED SUBJECT TO RETURN ON DEMAND AND IS NOT TO BE USED DIRECTLY OR INDIRECTLY IN ANY WAY DETRIMENTAL TO THE INTEREST OF TREND BUILDERS.

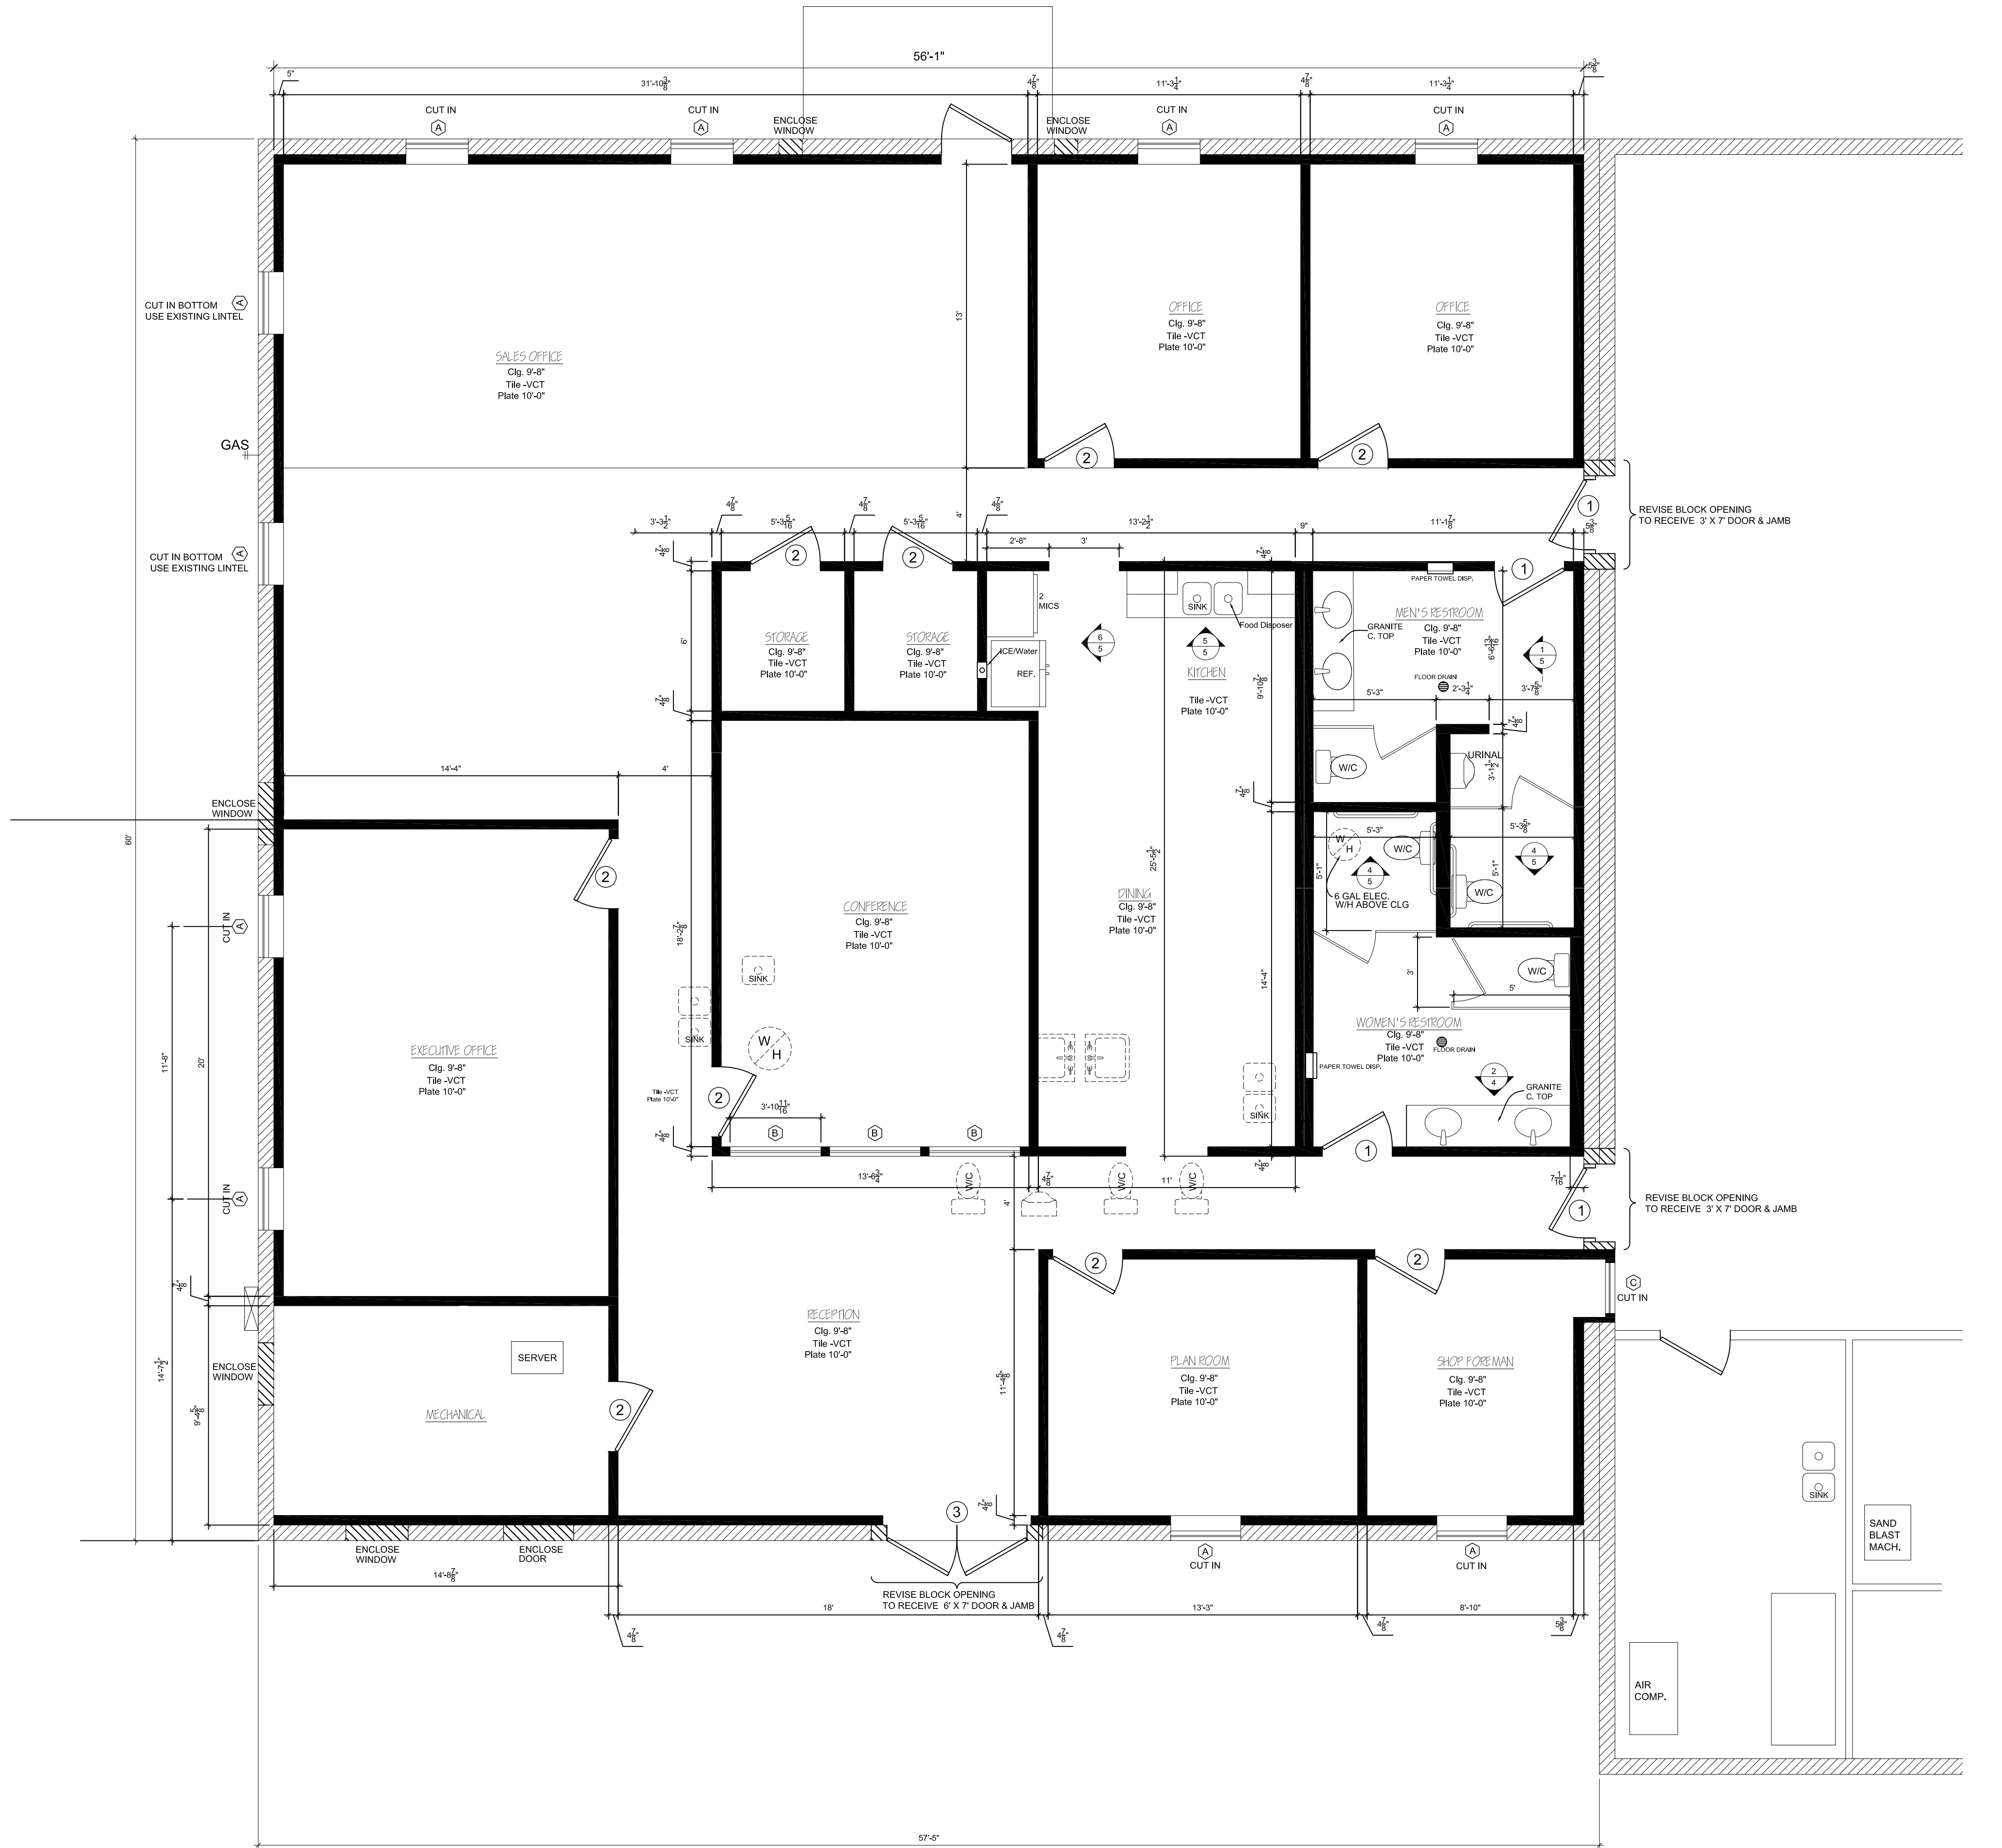

1
2 PROPOSED FLOOR PLAN
Scale 1/4" = 1'-0"

WINDOW SCHEDULE				
MARK	COLOR	Wth	HT	DESCRIPTION
(A)	BRZ	2 ⁸	6 ⁰	FIXED, ALUM., I. G., LOW - E, ARGON TEMPERED
(B)	BRZ	3 ¹⁰	4 ⁰	FIXED, ALUM., I. G., SINGLE GLAZED, TEMPERED
(C)	BRZ	2 ²	4 ⁰	FIXED, ALUM., I. G., SINGLE GLAZED, TEMPERED

DOOR SCHEDULE				
MARK	THK	Wth	HT	DESCRIPTION
(1)	1-3/4	3 ⁰	7 ⁰	S/C OAK / CLOSERS / PUSH-PULL PLATES
(2)	1-3/4	3 ⁰	7 ⁰	S/C OAK / LOCK SET
(3)	1-3/4	6 ⁰	7 ⁰	ALUM. FULL GLASS / LOCKSET / DEAD BOLT / TWIN


THIS DRAWING AND ALL INFORMATION THEREON IS THE PROPRIETARY PROPERTY OF TREND BUILDERS AND MUST NOT BE MADE PUBLIC OR COPIED. THIS DRAWING IS LOANED SUBJECT TO RETURN ON DEMAND AND IS NOT TO BE USED DIRECTLY OR INDIRECTLY IN ANY WAY DETRIMENTAL TO THE INTEREST OF TREND BUILDERS.

REVIS/DRAWN	Description
No. 4	Date 00/00/00
3	Date 00/00/00
2	Date 00/00/00
1	Date 00/00/00


PROJECT: Interior Renov.

DRAWING: Floor Plan


CUSTOMER:

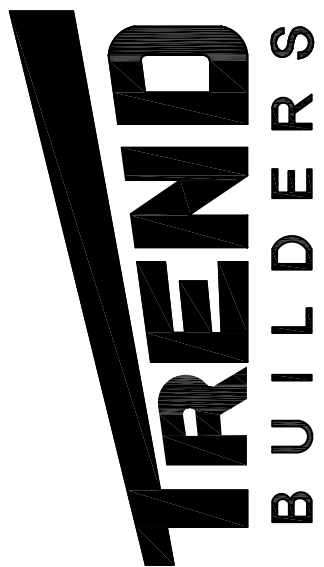

DATE: 12/20/17
SHEET: 2 OF 5

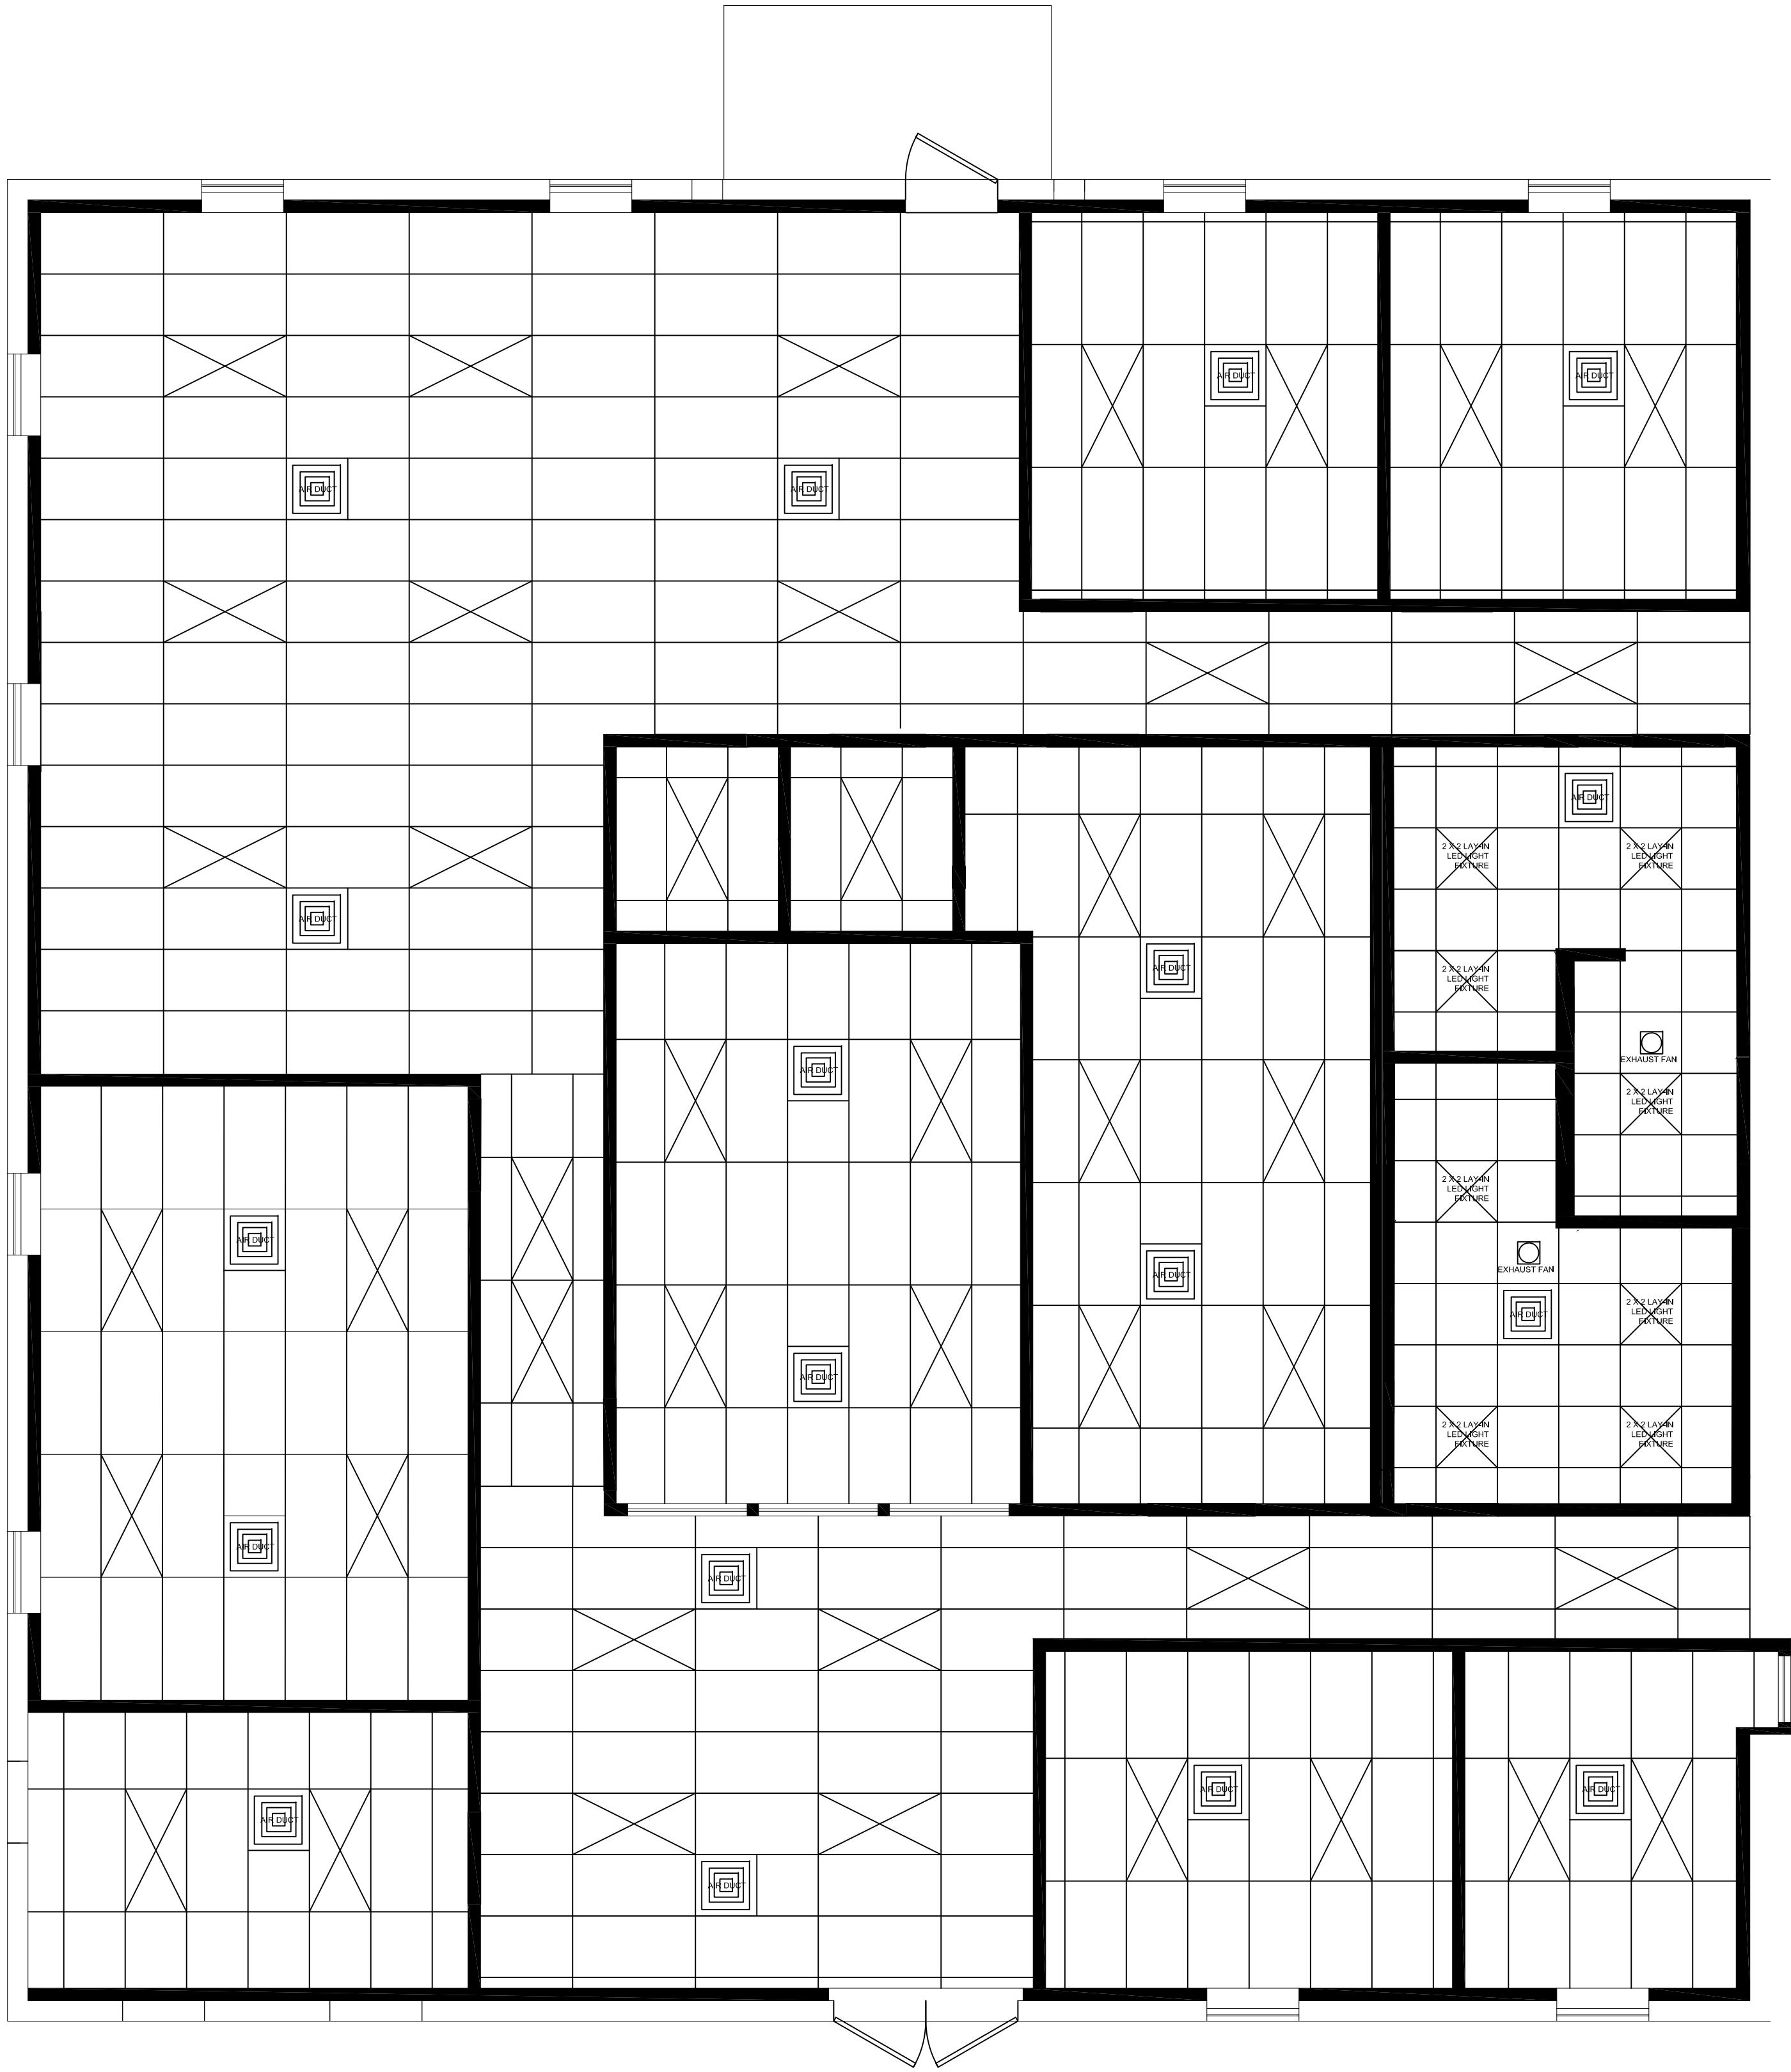

1
3 REFLECTIVE CLG PLAN
Scale 1/4" = 1'-0"

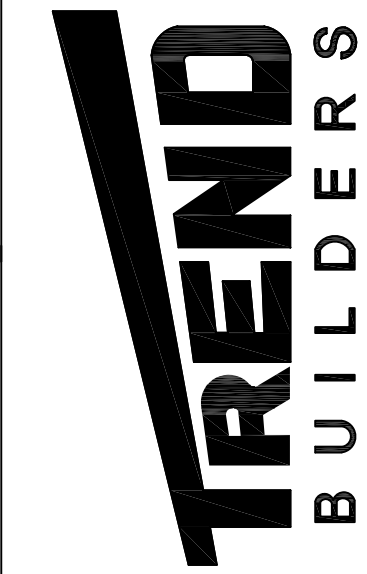


DATE:
12/20/17
SHEET:
3 OF 5

CUSTOMER:

PROJECT:
Interior Renov.
DRAWING:
Clg Plan

Revisions	No.	Date	Description
	4	00/00/00	
	3	00/00/00	
	2	00/00/00	
	1	00/00/00	


THIS DRAWING AND ALL INFORMATION THEREON IS THE PROPRIETARY PROPERTY OF TREND BUILDERS AND MUST NOT BE MADE PUBLIC OR COPIED. THIS DRAWING IS LOANED SUBJECT TO RETURN ON DEMAND AND IS NOT TO BE USED DIRECTLY OR INDIRECTLY IN ANY WAY DETRIMENTAL TO THE INTEREST OF TREND BUILDERS.

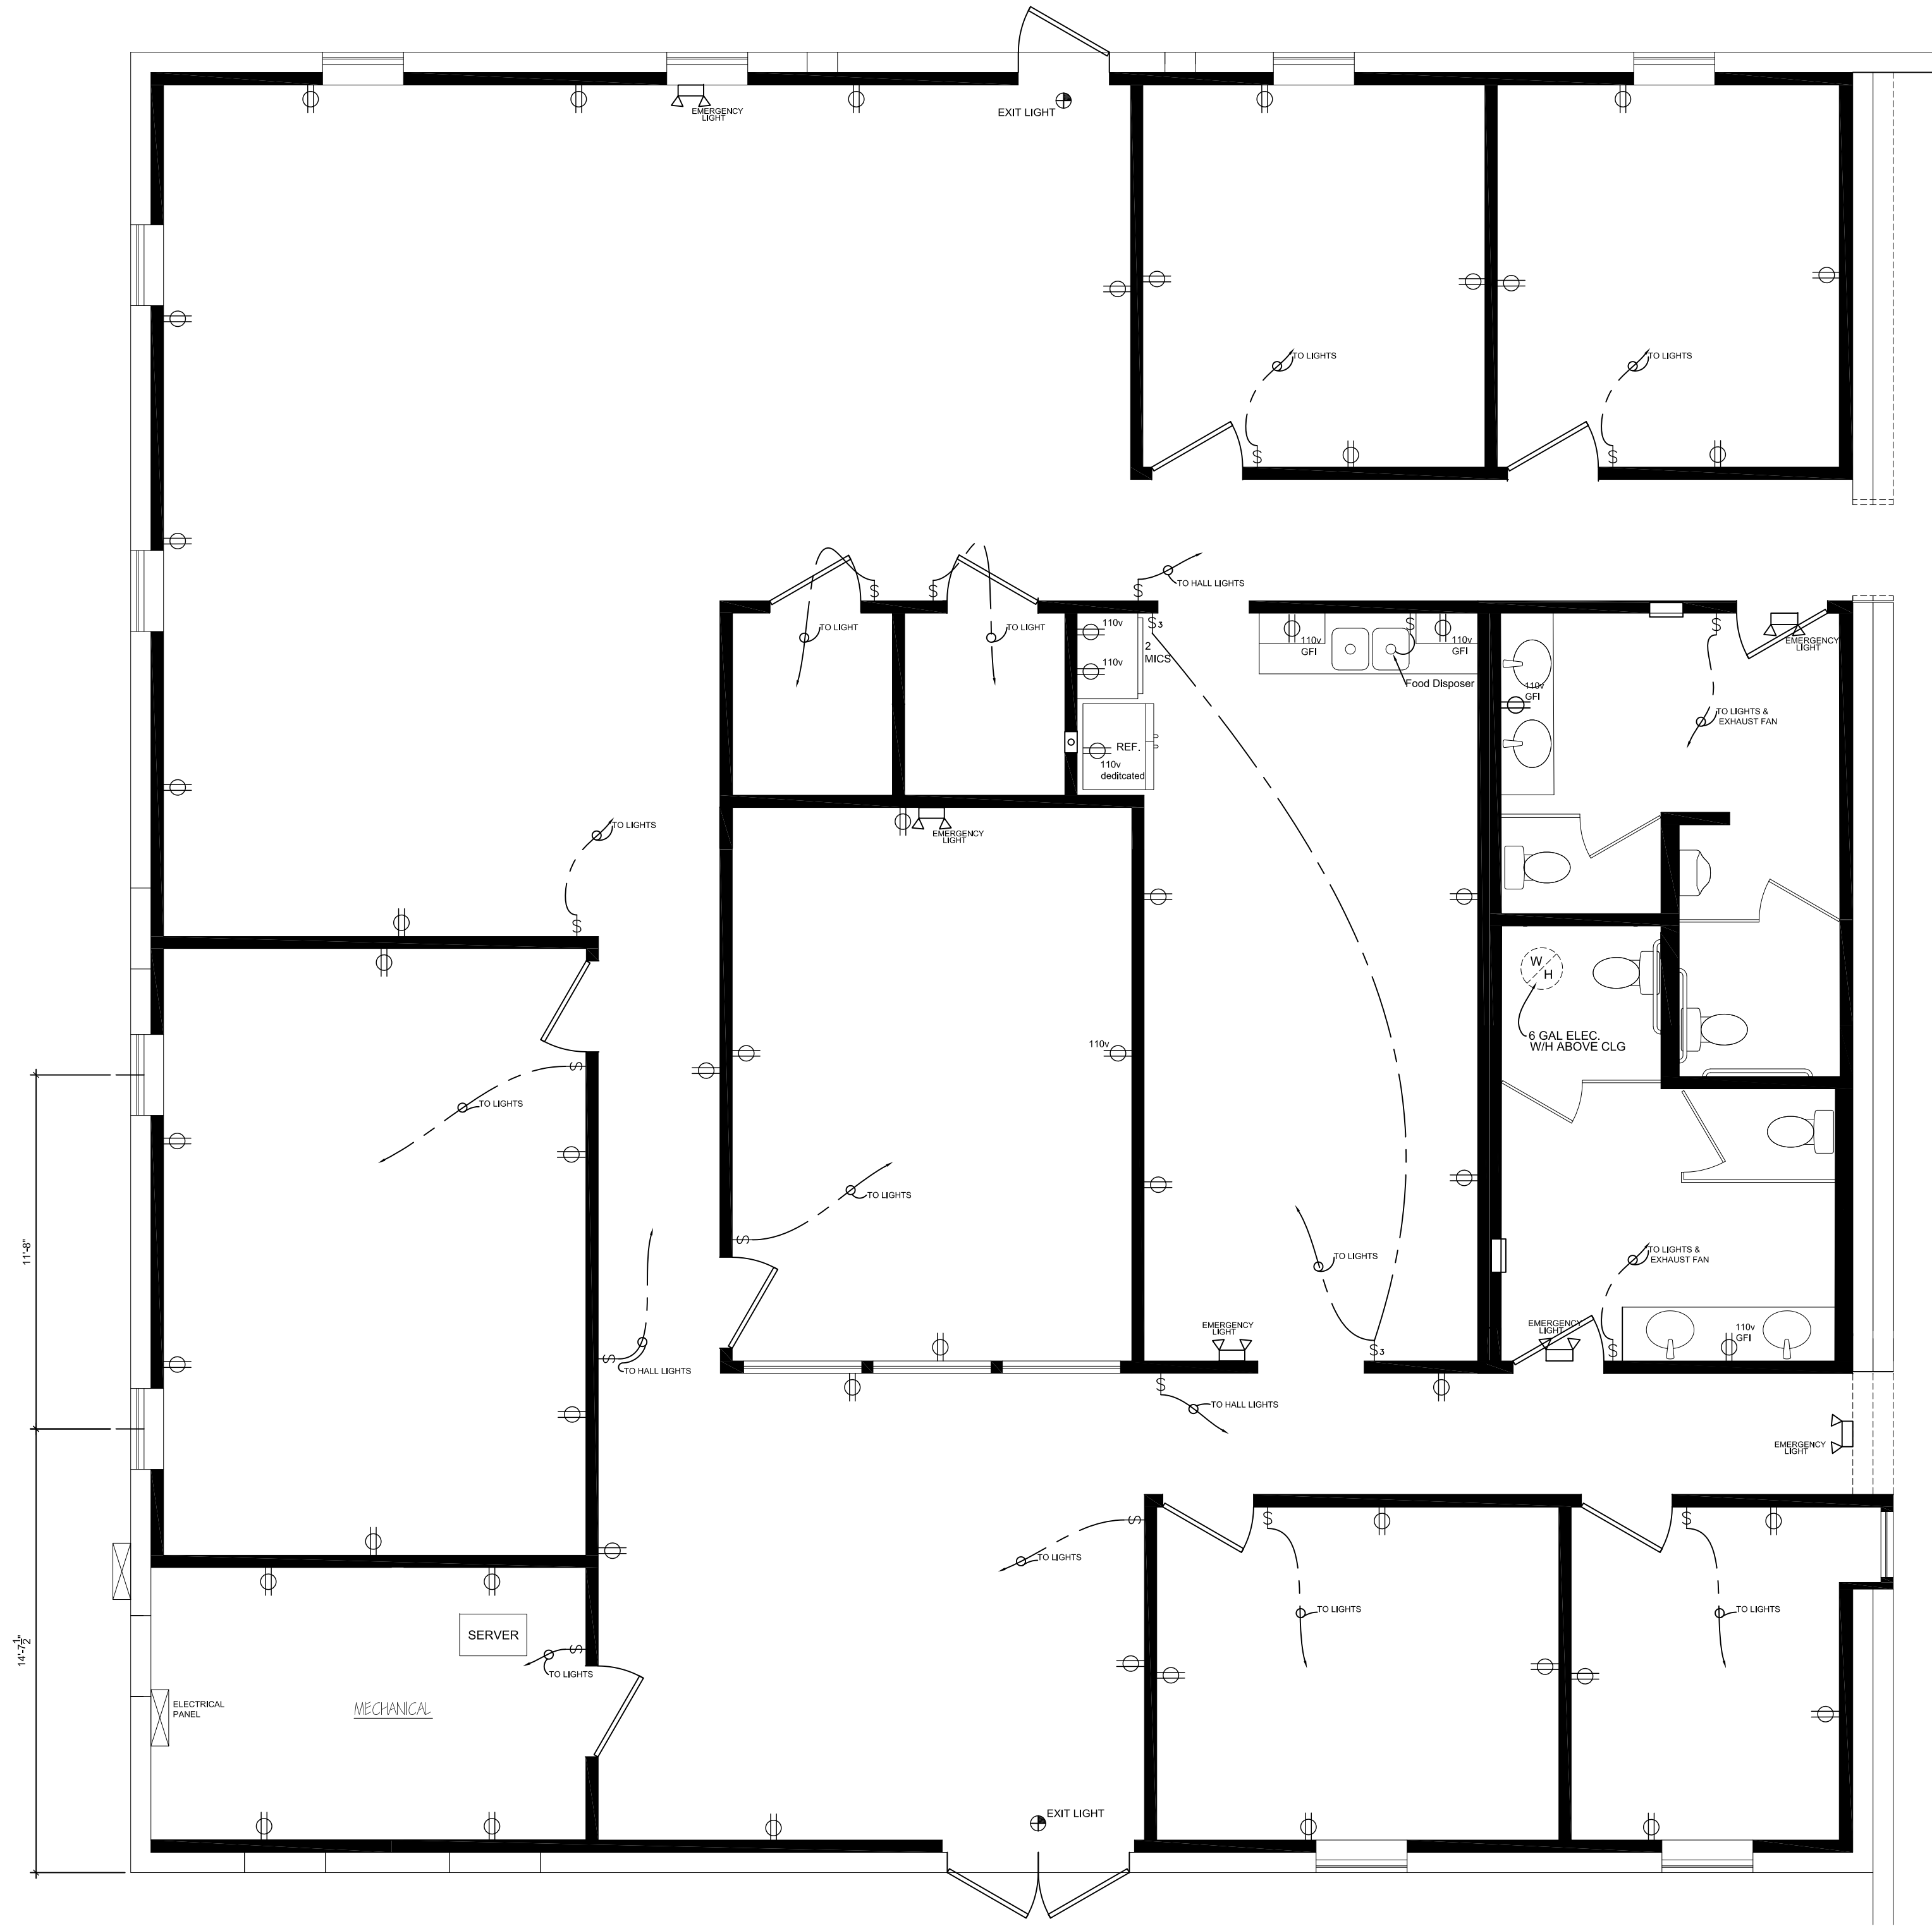

1

4

 ELECTRICAL PLAN
Scale 1/4" = 1'-0"

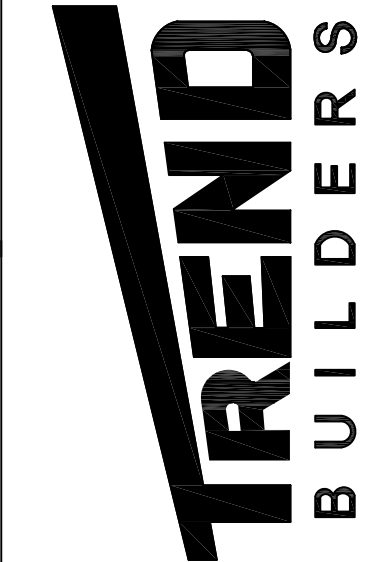



CUSTOMER:

PROJECT: Interior Renov.
DRAWING: Electrical Plan

REVISIONS	No.	Date	Description
	4	00/00/00	
	3	00/00/00	
	2	00/00/00	
	1	00/00/00	

DATE: 12/20/17
SHEET: 4 OF 5

THIS DRAWING AND ALL INFORMATION THEREON IS THE PROPRIETARY PROPERTY OF TREND BUILDERS AND MUST NOT BE MADE PUBLIC OR COPIED. THIS DRAWING IS LOANED SUBJECT TO RETURN ON DEMAND AND IS NOT TO BE USED DIRECTLY OR INDIRECTLY IN ANY WAY DETRIMENTAL TO THE INTEREST OF TREND BUILDERS.

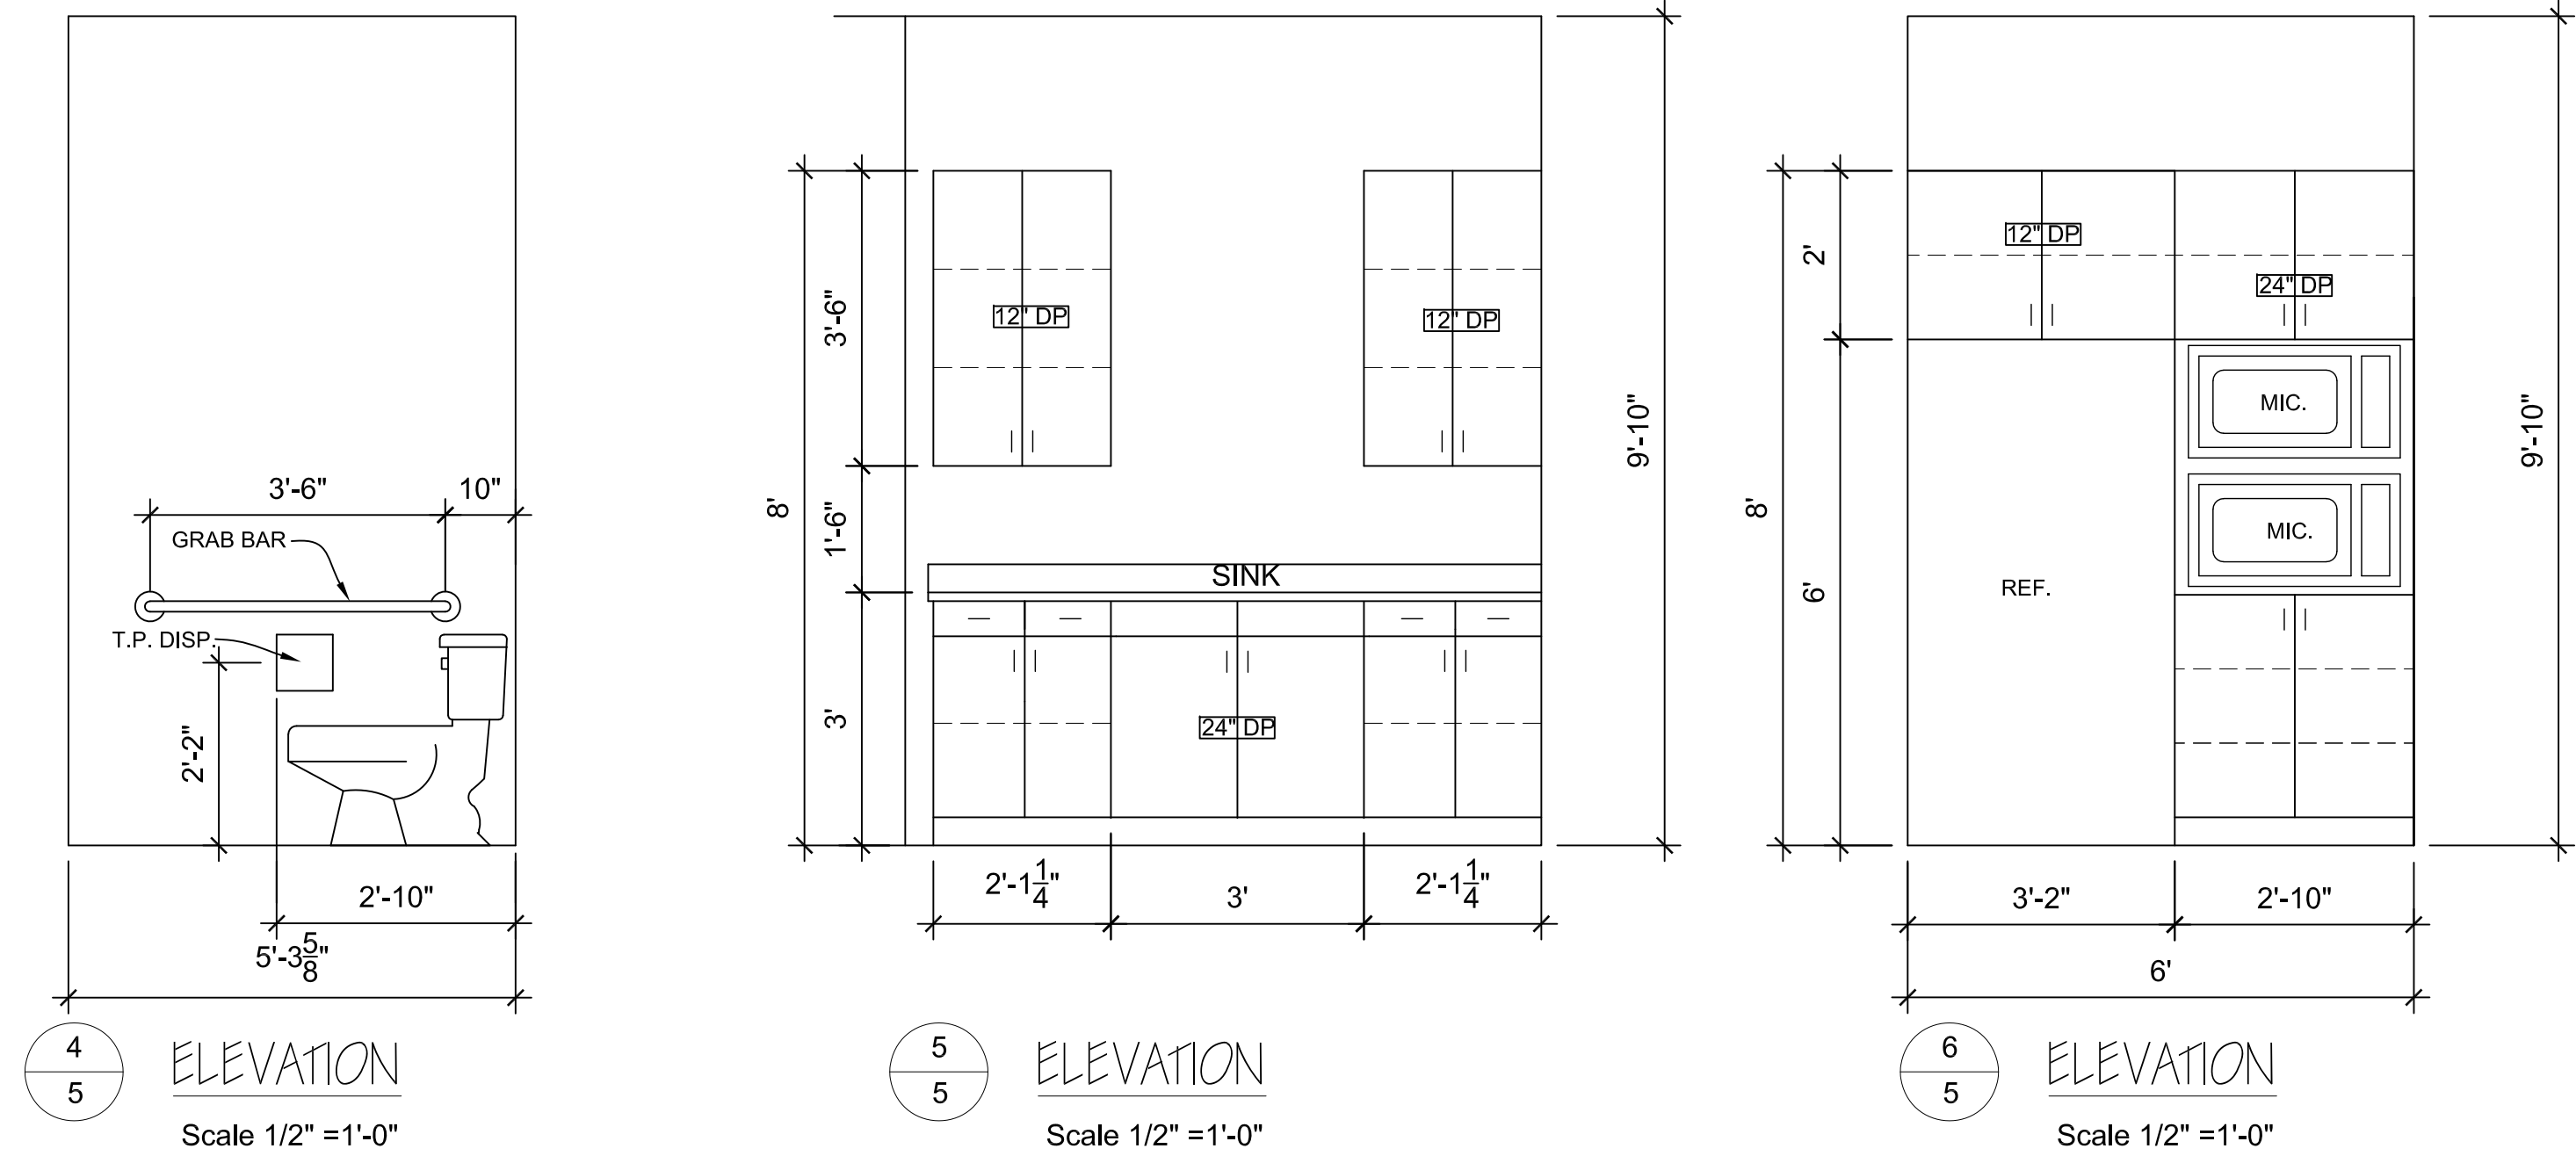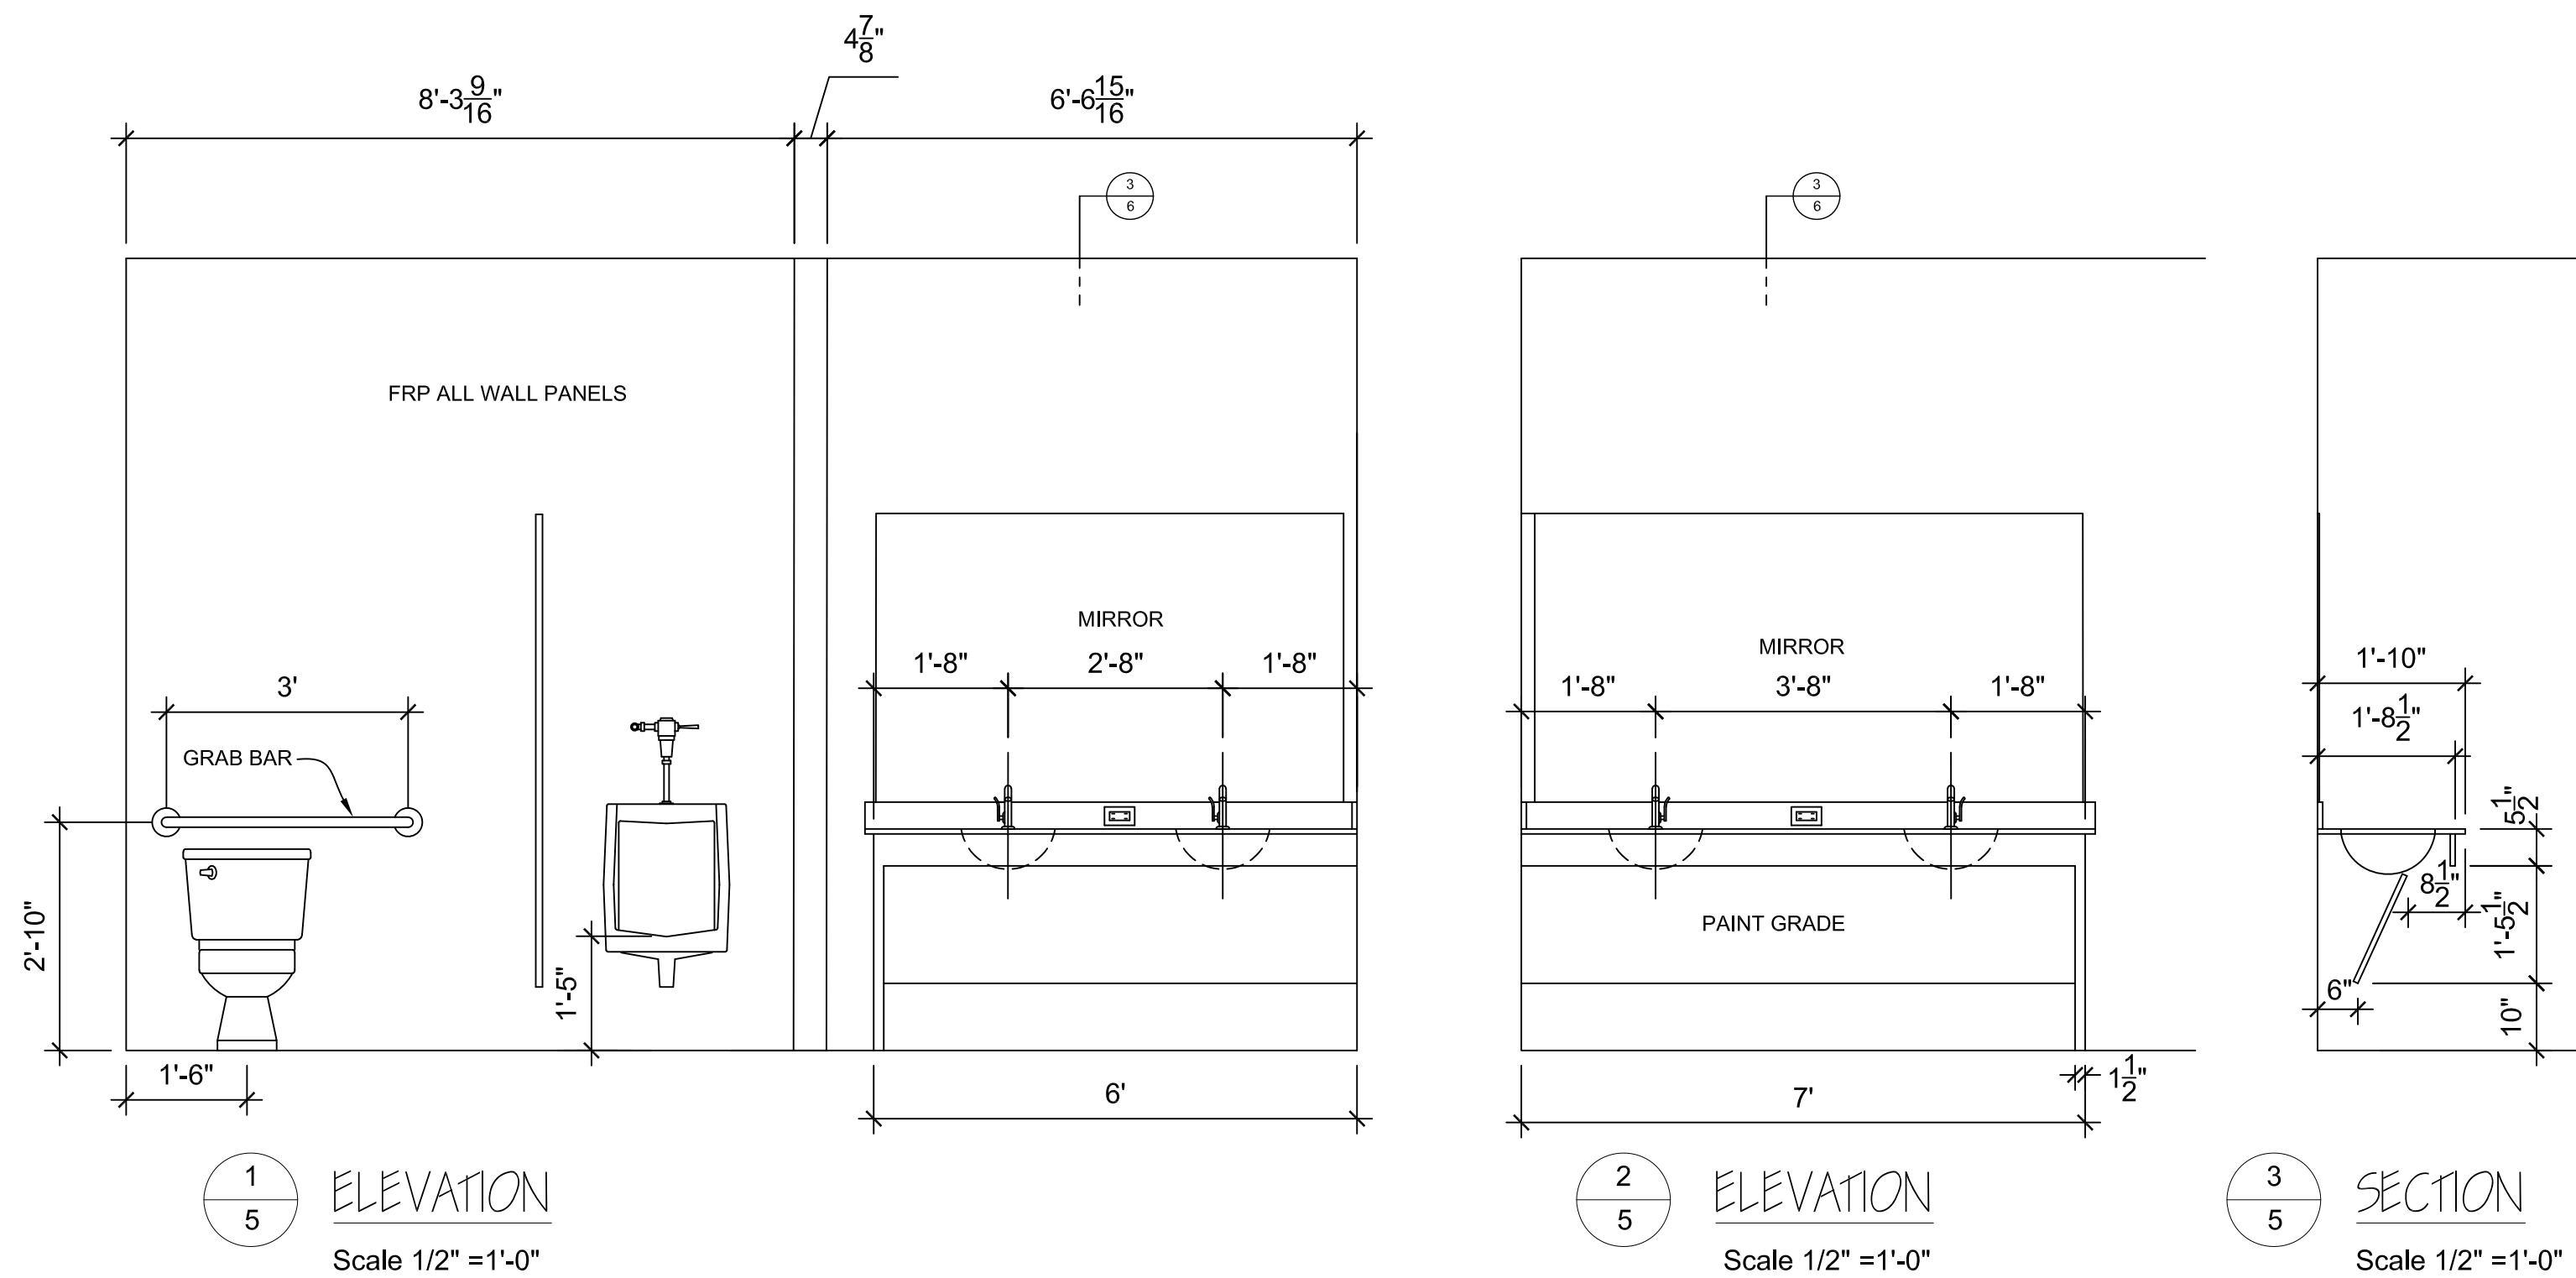

CABINET ELEVATIONS
Scale 1/2" = 1'-0"

CABINET SPECS.
 MATERIAL : PAINT GRADE
 DOORS : FLUSH (1/4" REVEAL)
 INTERIOR MAT'L : PLYWOOD
 DRAWERS : PLYWOOD, FULL EXT.
 FRAMELESS

THIS DRAWING AND ALL INFORMATION THEREON IS THE PROPRIETARY PROPERTY OF TREND BUILDERS AND MUST NOT BE MADE PUBLIC OR COPIED. THIS DRAWING IS LOANED SUBJECT TO RETURN ON DEMAND AND IS NOT TO BE USED DIRECTLY OR INDIRECTLY IN ANY WAY DETRIMENTAL TO THE INTEREST OF TREND BUILDERS.																
REVISIONS <table border="1"> <tr> <th>No.</th> <th>Date</th> <th>Description</th> </tr> <tr> <td>4</td> <td>00/00/00</td> <td></td> </tr> <tr> <td>3</td> <td>00/00/00</td> <td></td> </tr> <tr> <td>2</td> <td>00/00/00</td> <td></td> </tr> <tr> <td>1</td> <td>00/00/00</td> <td></td> </tr> </table>	No.	Date	Description	4	00/00/00		3	00/00/00		2	00/00/00		1	00/00/00		PROJECT: Interior Renov. DRAWING: Elevations
No.	Date	Description														
4	00/00/00															
3	00/00/00															
2	00/00/00															
1	00/00/00															
CUSTOMER:																
DATE: 12/20/17 SHEET: 5 OF 5																

